


PROPOSED PLAN OF (G+III) STORIED RESIDENTIAL BUILDINGS (HEIGHT - 12.5 M.) AT K.M.C. PREMISES NO.- 140A, SANTOSH ROY ROAD, WARD NO.- 123, BR. NO.- XVI, UNDER J.L. NO.- 14, R.S. KHATIAN NO.- 489, DAG NO.- 404, MOUZA - SARKELHAT, P.S. - HARIDDEVPUR, KOLKATA - 700 008.

N
SCALE 1:150

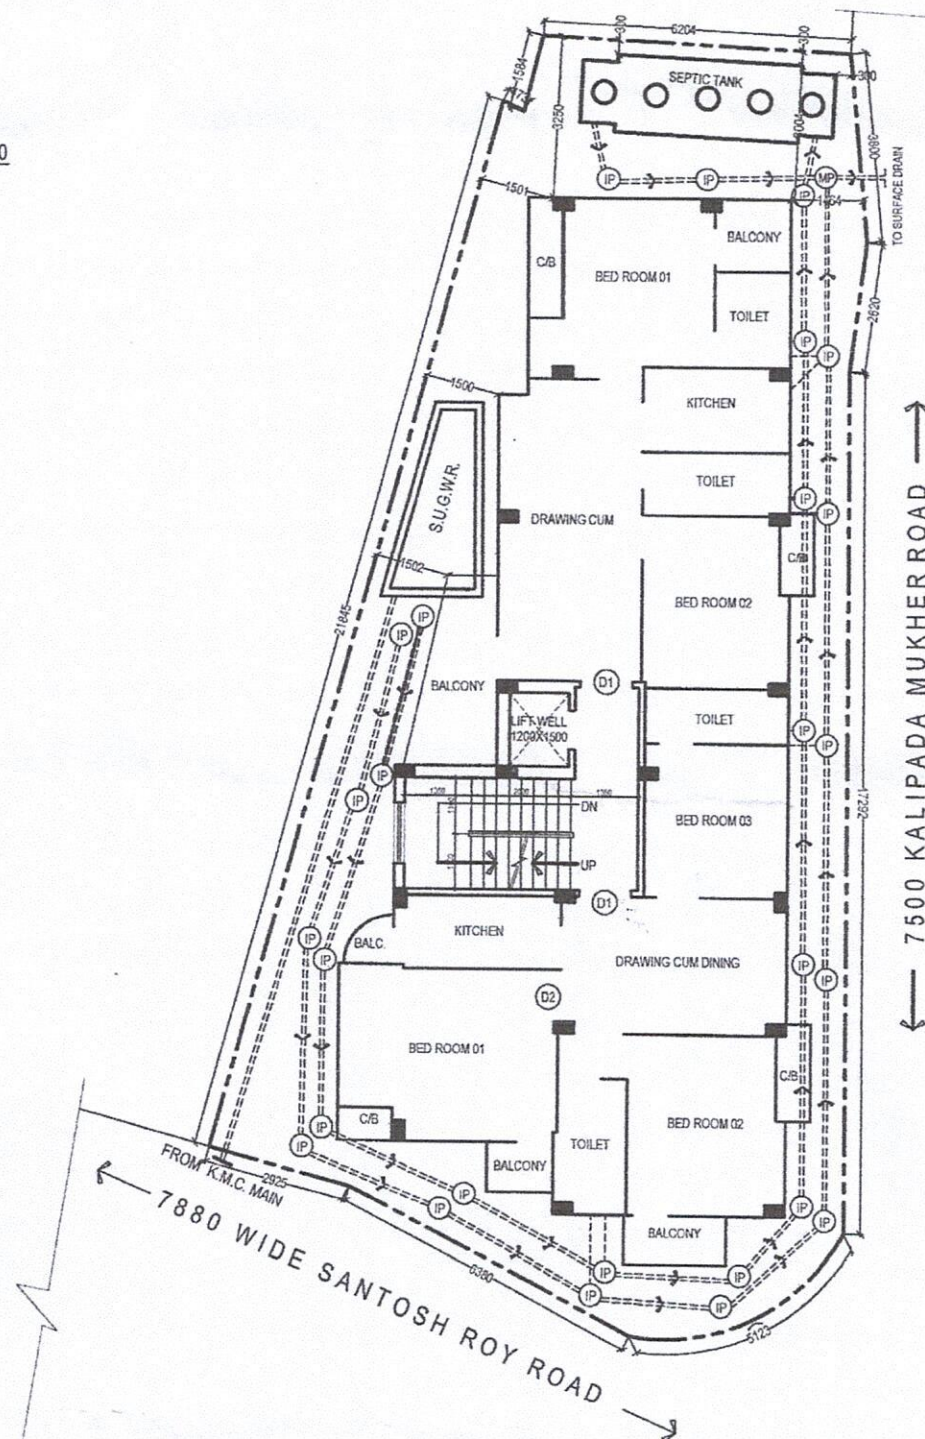

DRAINAGE LAYOUT FOR TYPICAL
(FIRST, SECOND & THIRD) FLOOR PLAN

Kalyan Halder
Kalyan Halder
SIGNATURE OF OWNER/S

Samir Chandra Paul
SAMIR CH. PAUL

LICENCE PLUMBER OF
THE KOLKATA MUNICIPAL CORPORATION
WATER SUPPLY & DRAINAGE
(W.S) LIC. NO. DATE=
(DRAINAGE) LIC. NO. 789 DATE=01/08/19

SIGNATURE OF PLUMBER

Suhreed Mahapatra
SUHREED MAHAPATRA
(B. Arch)
COUNCIL OF ARCHITECTURE
REGN NO - CA2004/33392

SUHREED MAHAPATRA
CA/2004/33392
SIGNATURE OF ARCHITECT