


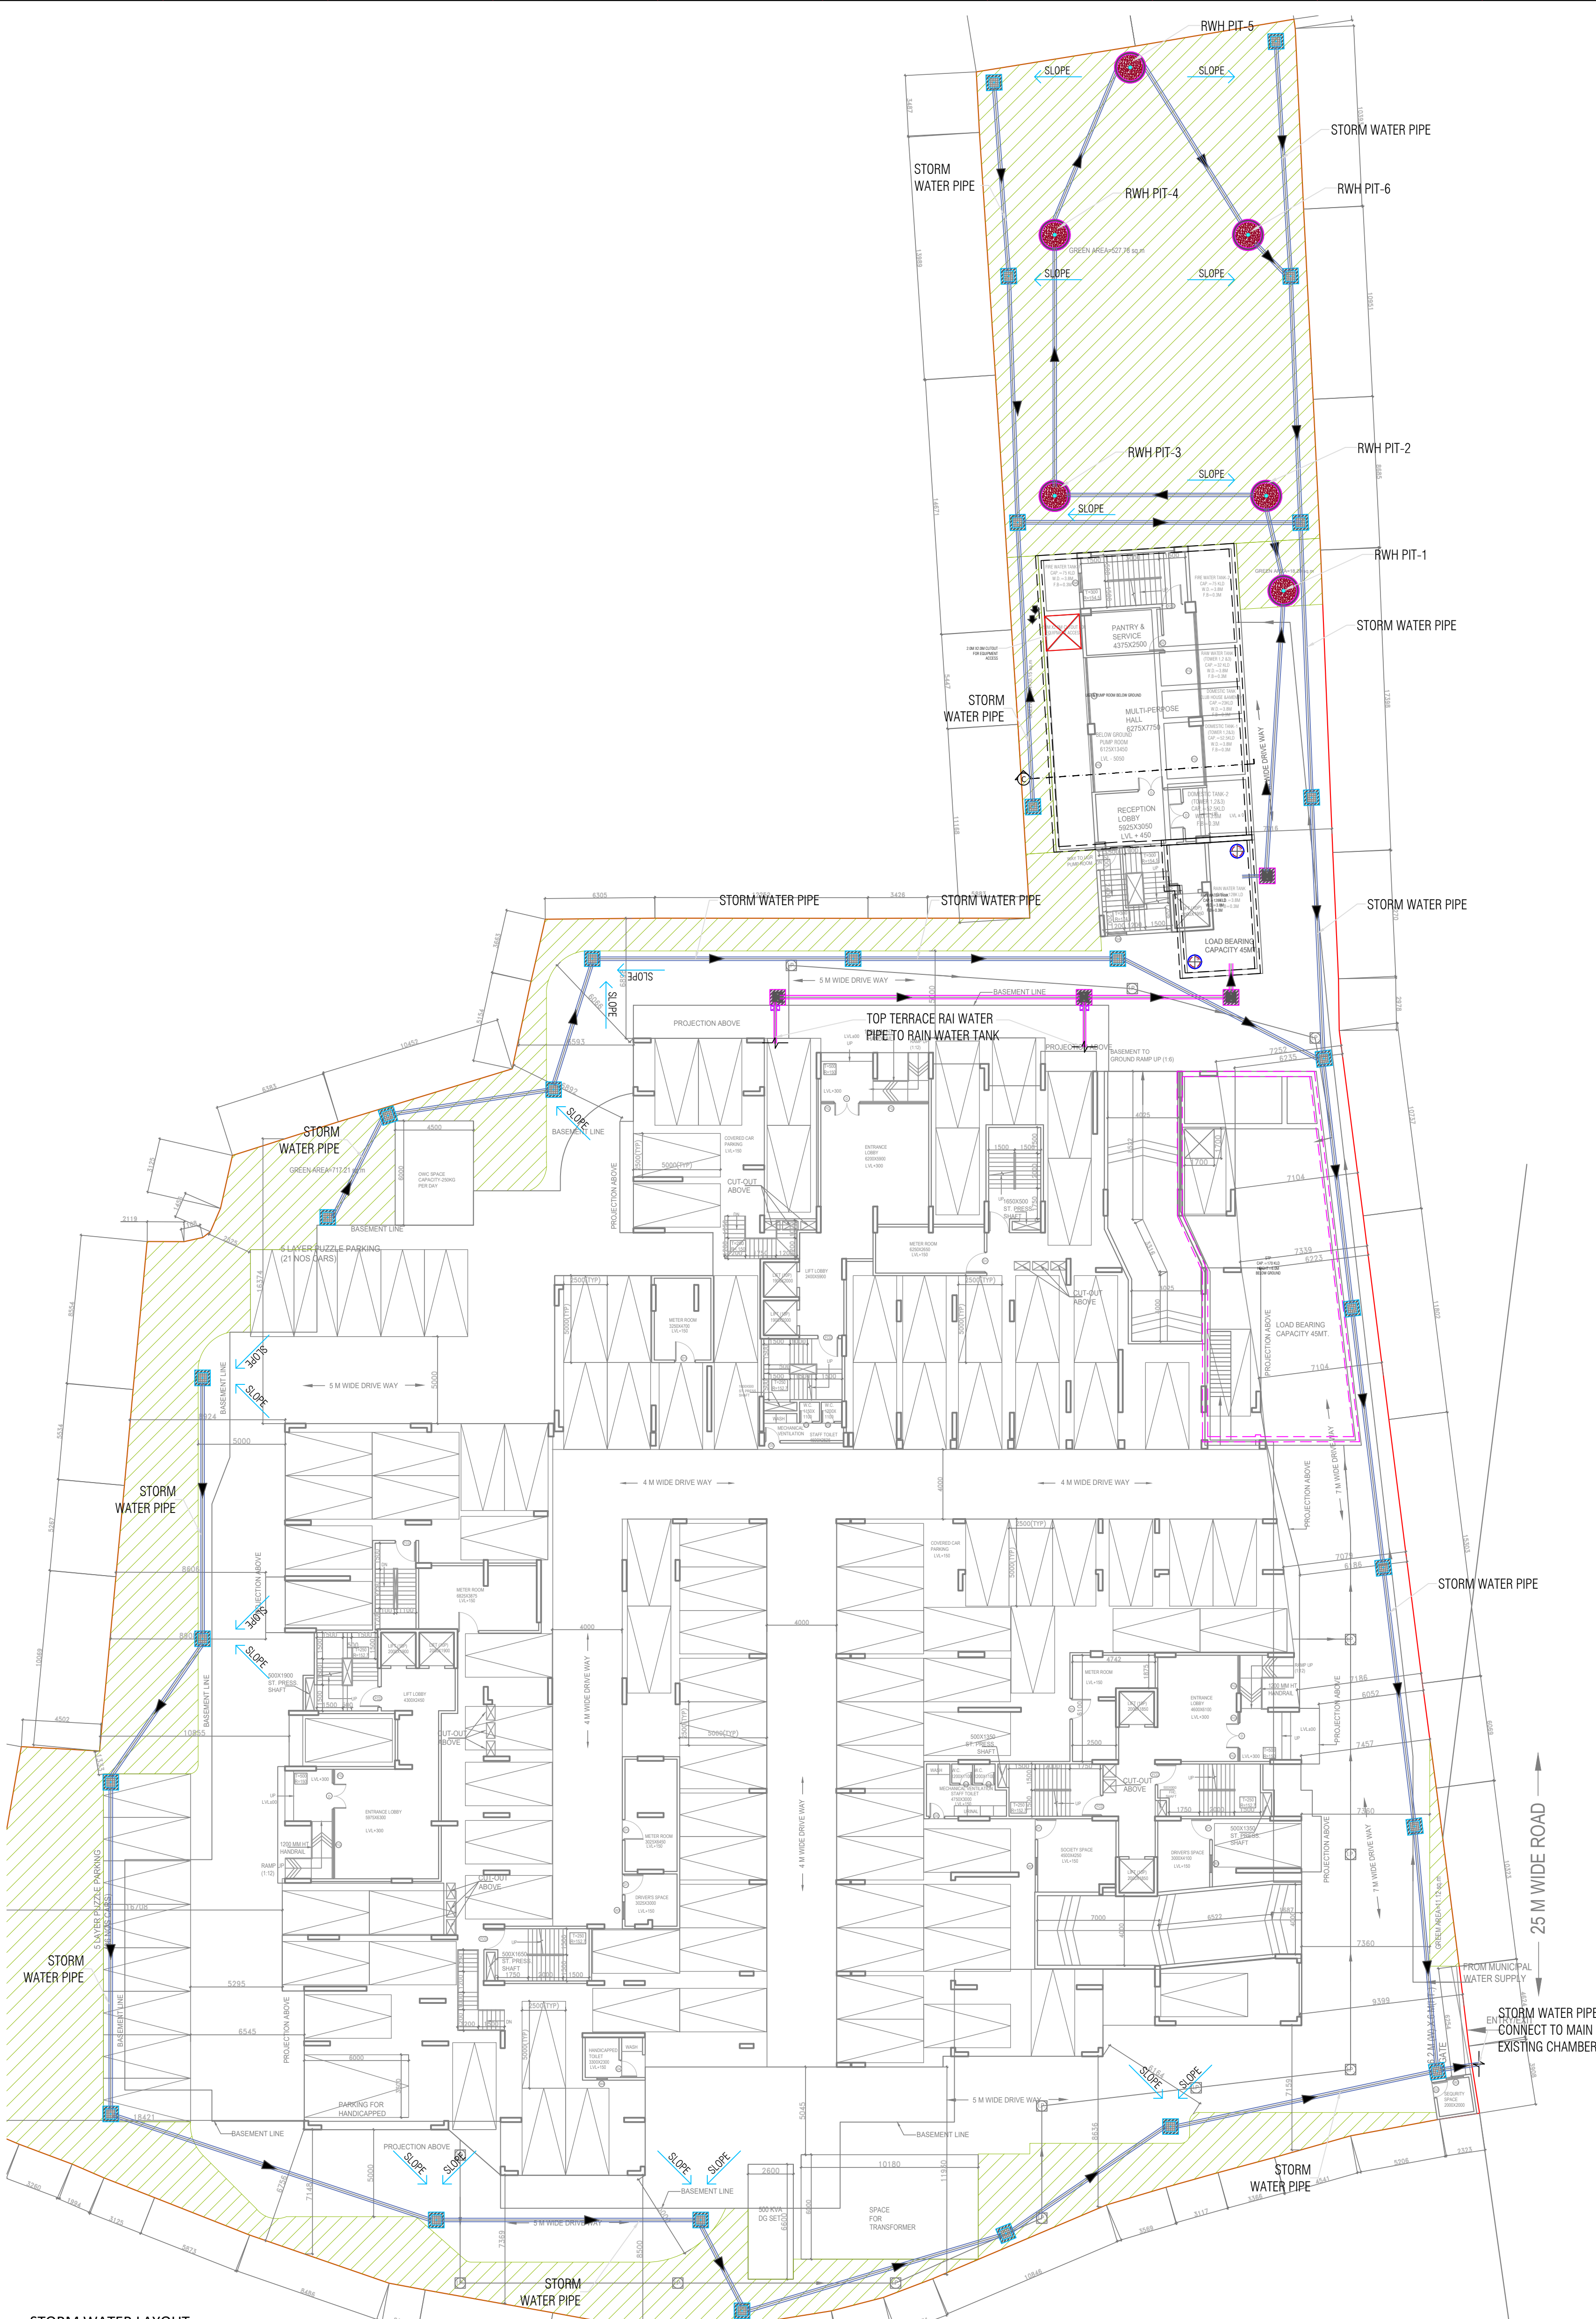


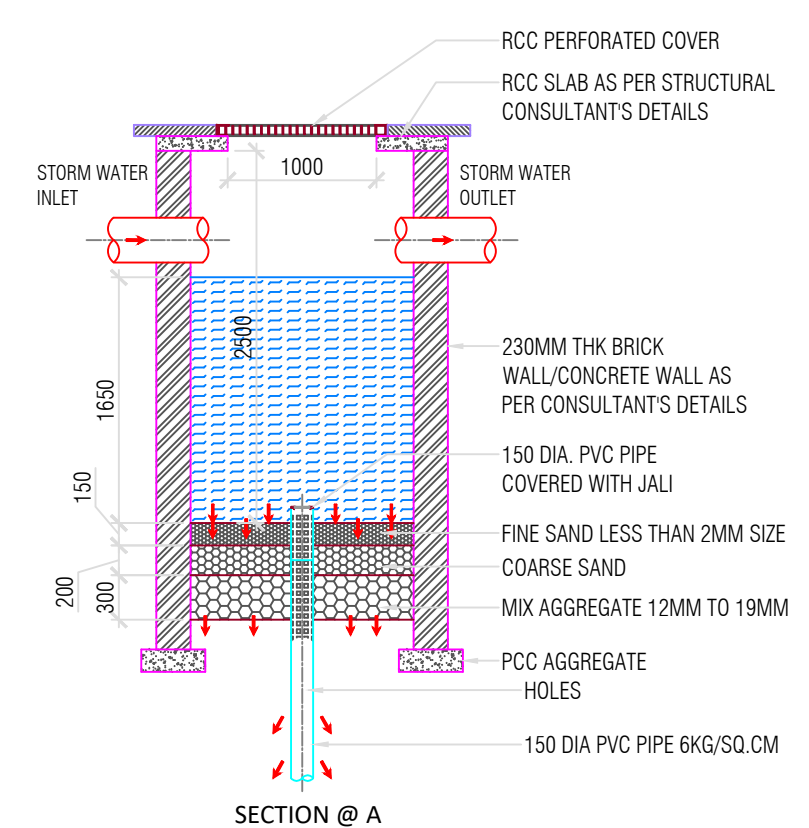

STORM WATER LAYOUT
SCALE - 1:200

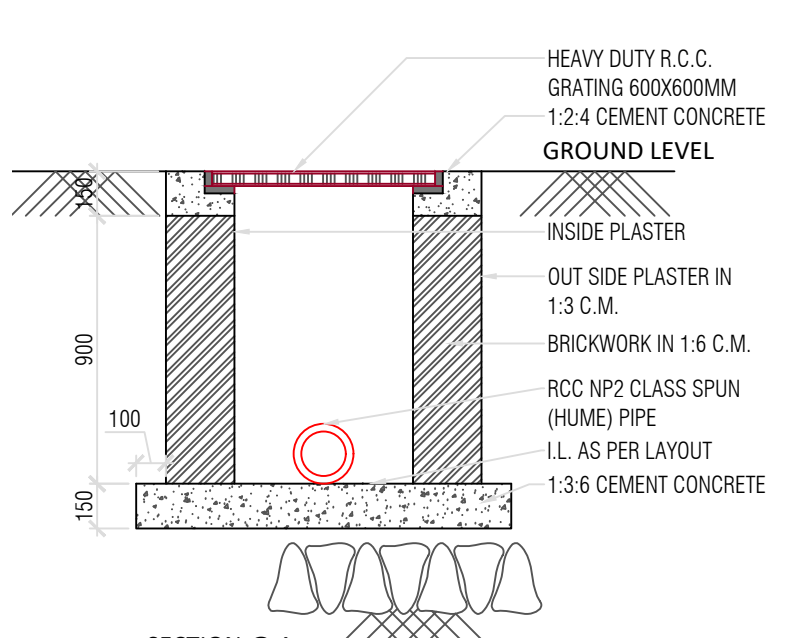


DETAILS FOR TERRACE RAIN WATER RECHARGE PIT
(Ø1.5Mx2.5M(D))
SCALE 1:50

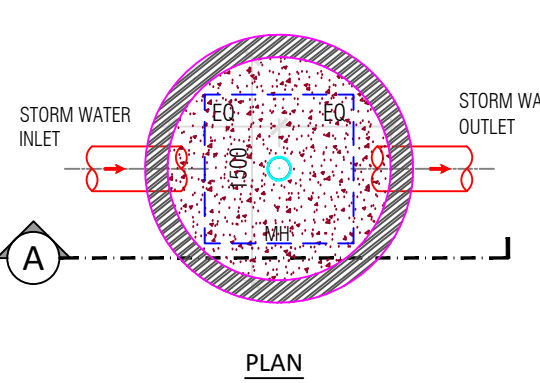

SECTION @ A
TYPICAL STORM WATER COLLECTION CHAMBER
SCALE 1:25

PLUMBING LEGENDS	
DESCRIPTION	SYMBOL
Ø160mm STORM WATER PIPE SHOWN AS	
Ø160mm TOP TERRACE RAIN WATER PIPE TO UGT SHOWN AS	
Ø200mm STORM WATER PIPE SHOWN AS	
FLOW DIRECTION SHOWN AS	
FLOOR SLOPE SHOWN AS	
600X600MM RAIN WATER CHAMBER WITH PERFORATED COVER SHOWN AS	
Ø1.5mtr RECHARGE PIT SHOWN AS	
600X600MM RAIN WATER CHAMBER WITH RECESS COVER SHOWN AS	
PLUMBING CUTOUT AS SHOWN	
RETAINING CUTOUT AS SHOWN	

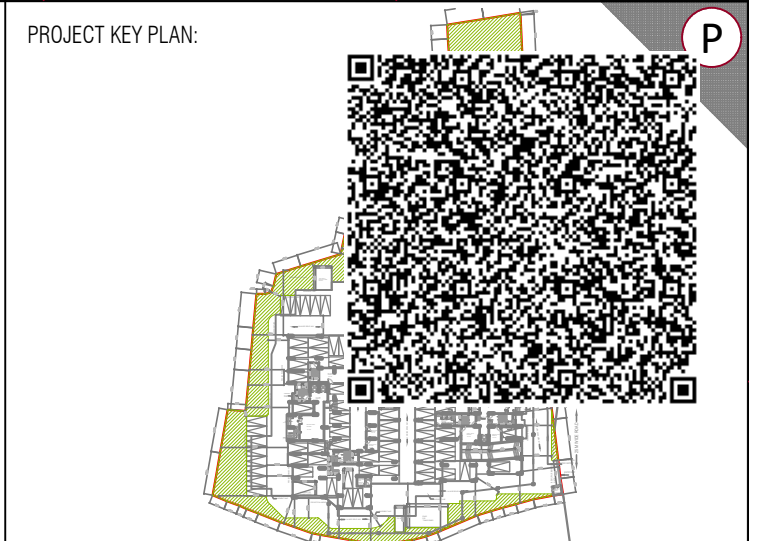

- GENERAL NOTES:
- THIS DRAWING IS A COPYRIGHT.
 - CONTRACTOR SHALL VERIFY ALL DIMENSIONS, MEMBER SIZES AND FIELD CONDITIONS PRIOR TO COMMENCING ANY WORK AND SHALL REPORT ANY DISCREPANCIES OR CONFLICTS TO THE CONSULTANT.
 - ALL DIMENSIONS SHOWN ON THE DRAWING ARE INTENDED AS A GUIDELINES AND MUST BE VERIFIED DURING LAYOUT. DO NOT SCALE THIS DRAWING.
 - THE CONTRACTOR IS RESPONSIBLE FOR THE COORDINATION OF SERVICES INTO THE WORKS AS MAY BE REQUIRED.
 - PREPARE WORKING DETAILED DRAWING / SHOP DRAWING FOR APPROVAL IF REQUIRED BY CONSULTANT.
 - READ THIS DRAWING IN CONJUNCTION WITH RELEVANT ARCHITECTURAL, STRUCTURAL AND SERVICES DRAWINGS, SPECIFICATIONS, DETAILS AND CONTRACT DOCUMENTS.
 - ANY VARIATION / DISCREPANCIES TO BE HIGHLIGHTED IMMEDIATELY BEFORE COMMENCING ANY WORK.

06/01/2025	FIRST UPLOAD	R0
DATE	DESCRIPTION	REV

CONCEPTUAL DRAWING			
REFERENCE DRAWING	DRAWING NO.	DATE	REV
ARCHITECTURAL	---	---	-
STRUCTURAL	---	---	-
PROJECT:	PANSARI DEVELOPERS LTD RESIDENTIAL GOPALPUR PROJECT AT KOLKATA.		
OWNER:	PANSARI DEVELOPERS LIMITED KOLKATA.		
STRUCTURAL:	ADROIT CONSULTANTS KOLKATA		
ARCHITECT:	MAHESHWARI ASSOCIATE		

MEP CONSULTANT			
 s n joshi consultants pvt ltd 5th Floor, The Metropolitan, Shivajinagar, Pune 411005 Tel : 99755 71105 web - www.snjosiconsultants.com			
PROJECT NO.	4165		
TITLE:	EXTERNAL STORM WATER LAYOUT		
BLDG. #	DRAWING NUMBER	REV. NO.	
--	4165-CON-PHE-00-EXTL-STL	R0	
DATE	SCALE	DRAWN	DESIGNED
06/01/2025	1:200	DEEPAK H.	MANISH N.
			CHECKED
			PRASHANT M