

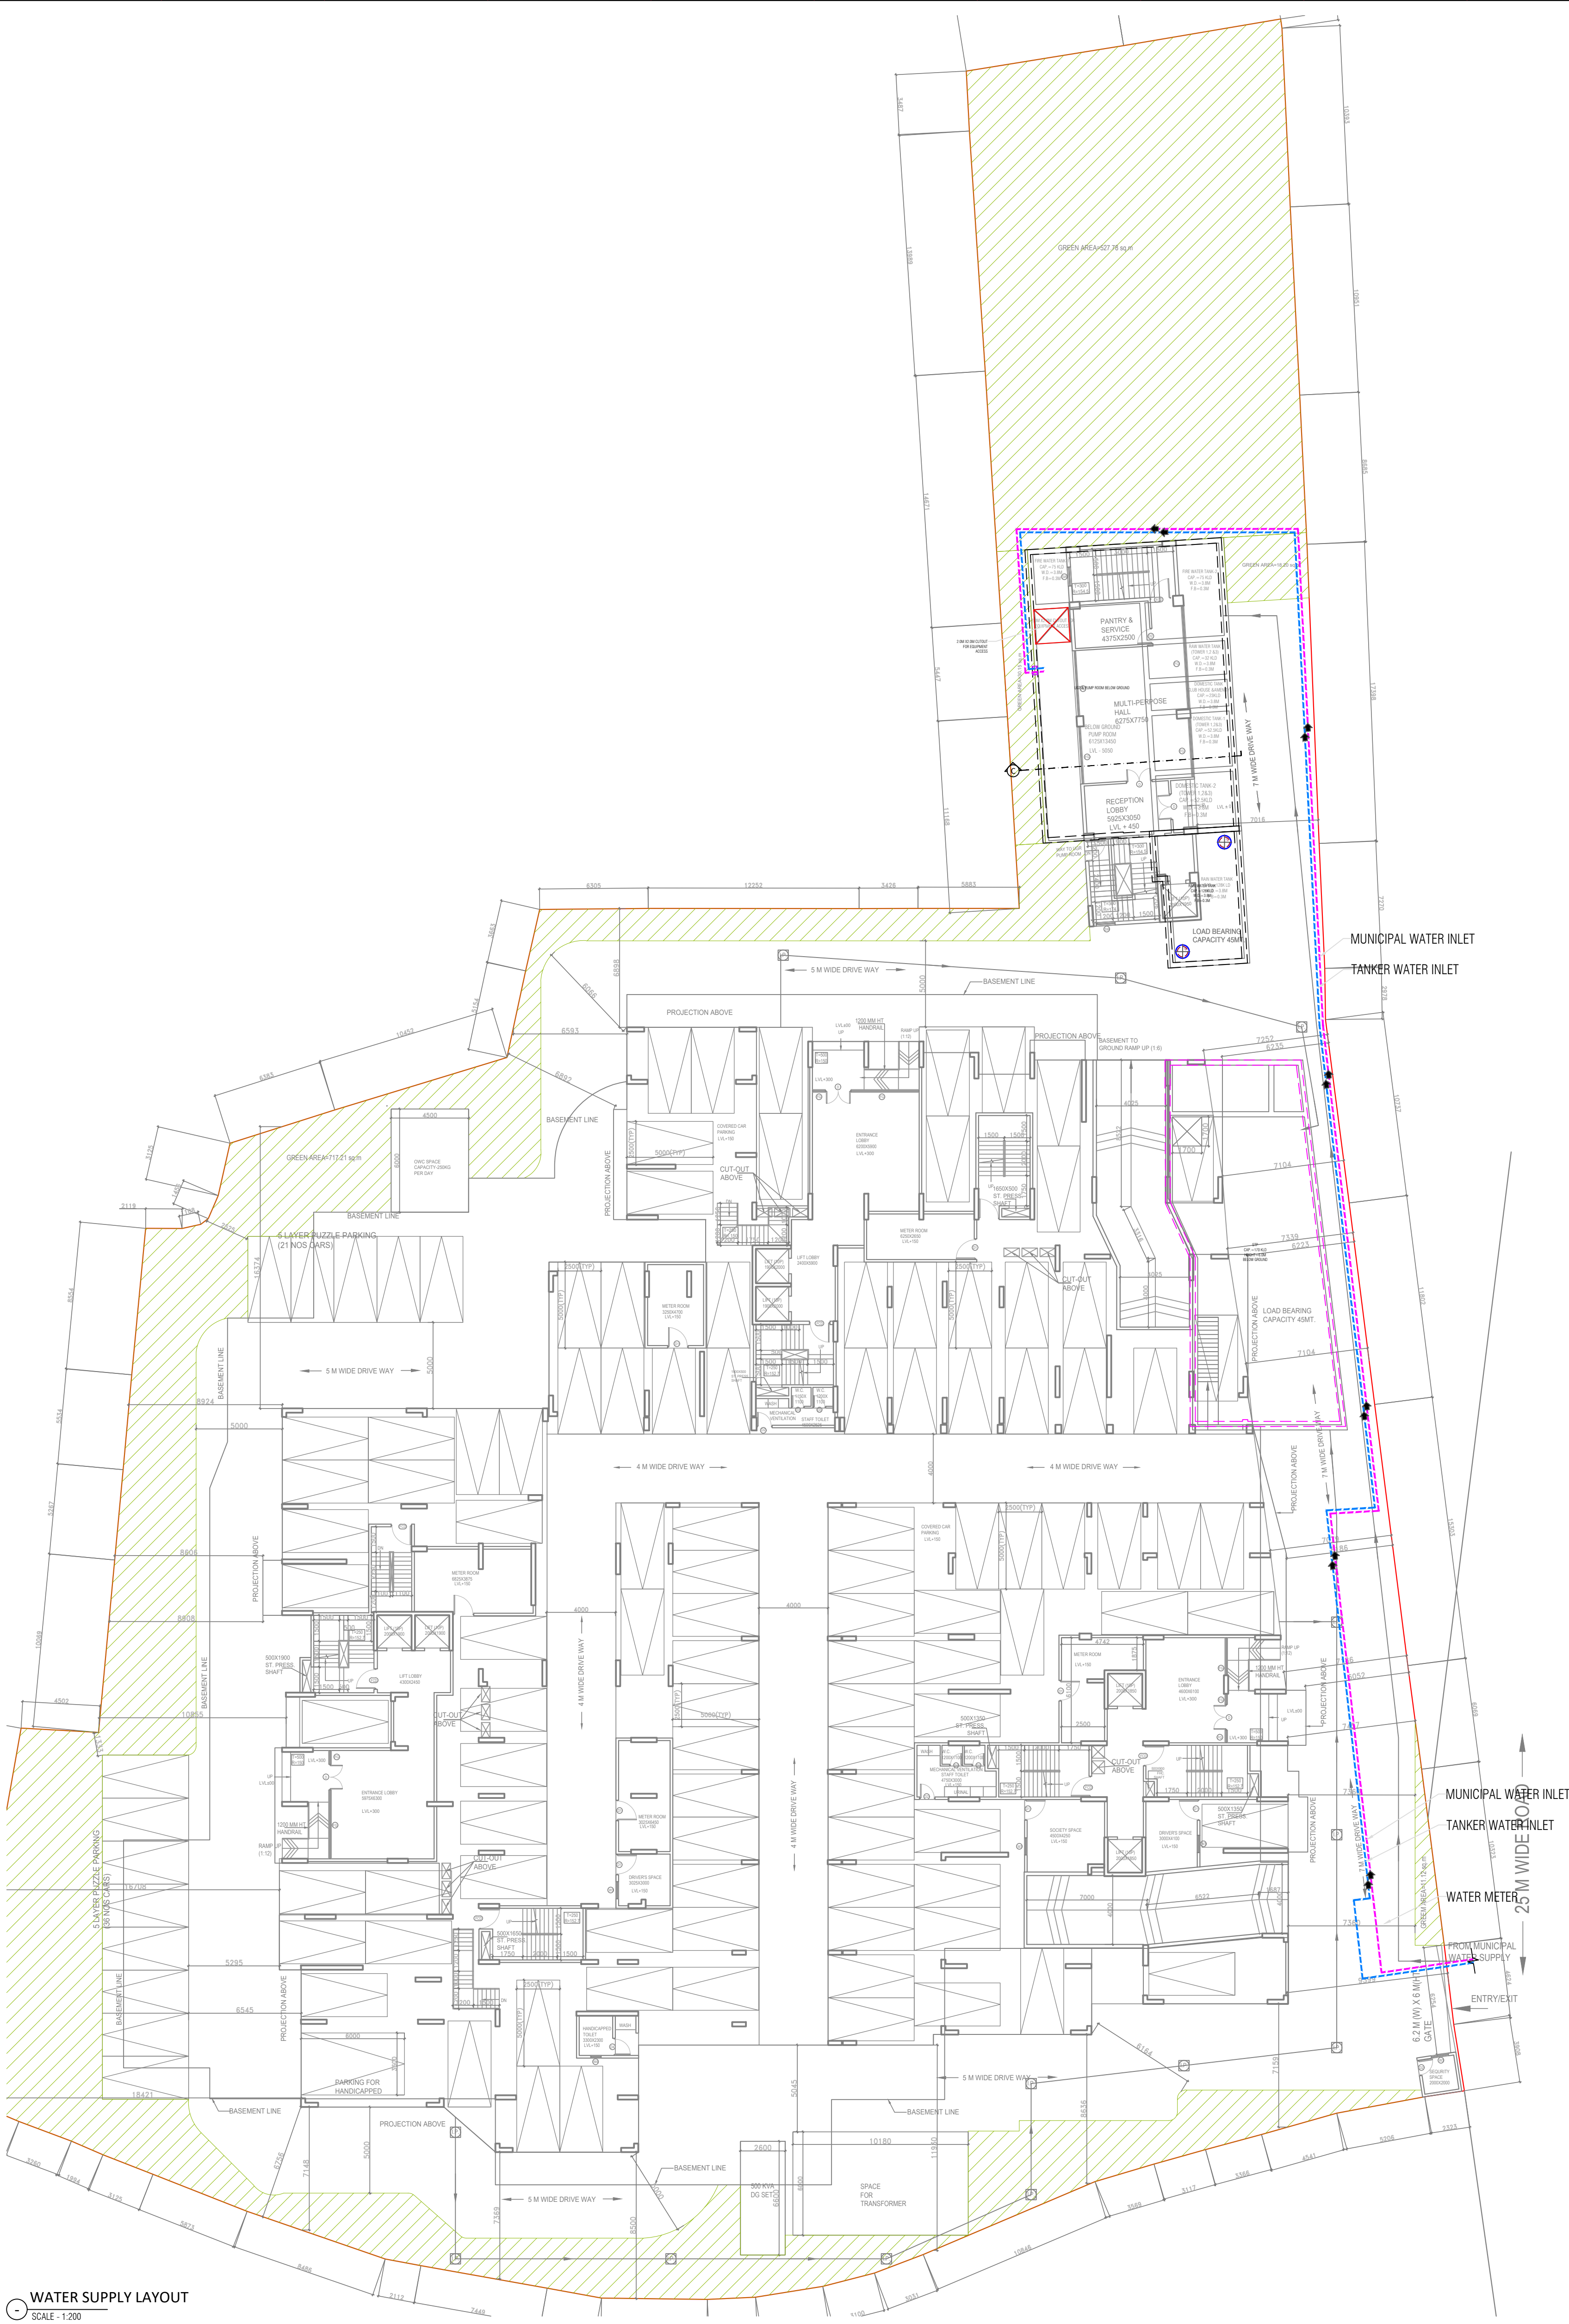


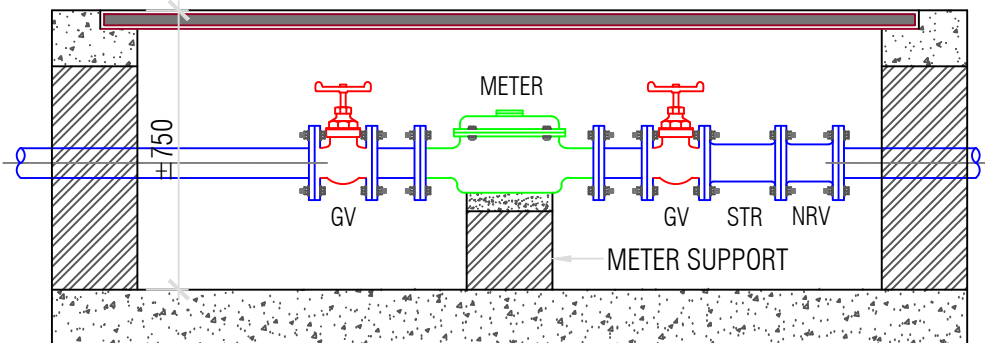


WATER SUPPLY LAYOUT
SCALE - 1:200

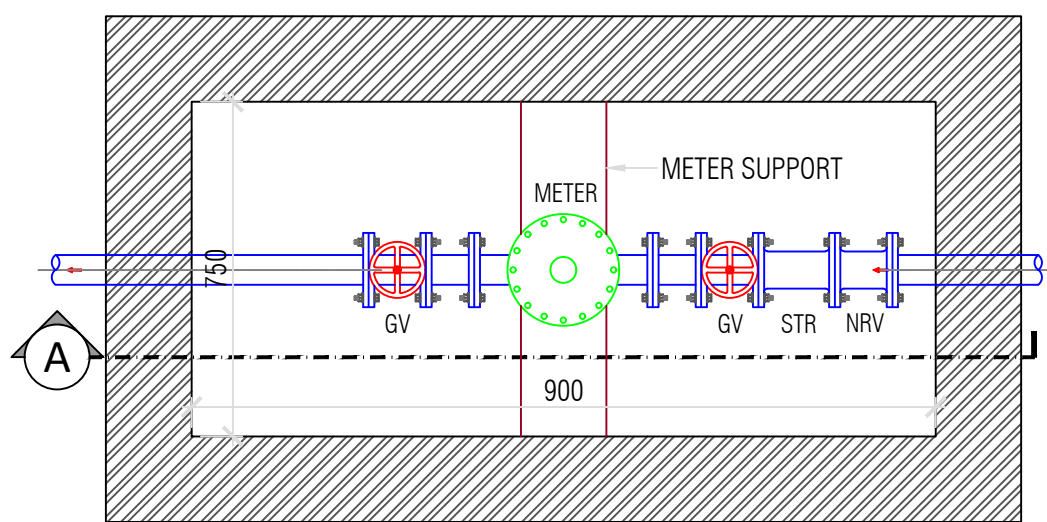

SECTION @ A
WATER METER CHAMBER DETAILS
SCALE 1:25

PLUMBING LEGENDS	
DESCRIPTION	SYMBOL
MUNICIPAL WATER SUPPLY INLET	
TANKER WATER SUPPLY INLET	
CUT-OUT IN FLOOR	
BALL VALVE	
FLOW DIRECTION	
900X750MM WATER METER	

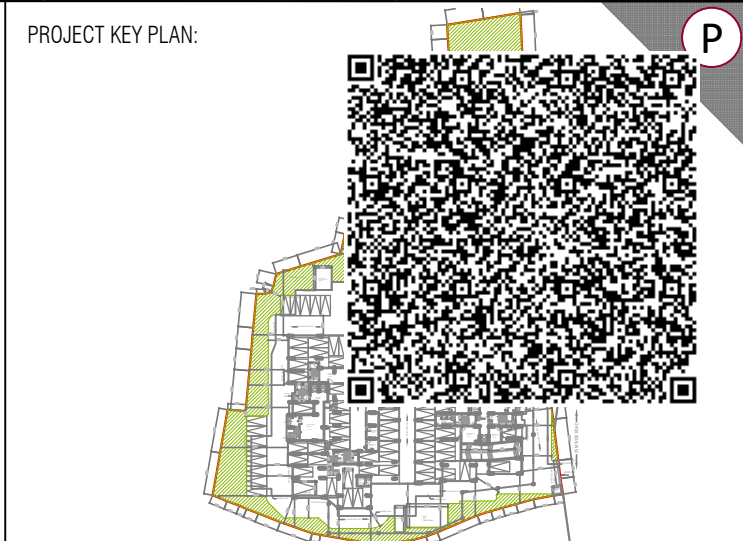

- GENERAL NOTES:
- THIS DRAWING IS A COPYRIGHT.
 - CONTRACTOR SHALL VERIFY ALL DIMENSIONS, MEMBER SIZES AND FIELD CONDITIONS PRIOR TO COMMENCING ANY WORK AND SHALL REPORT ANY DISCREPANCIES OR CONFLICTS TO THE CONSULTANT.
 - ALL DIMENSIONS SHOWN ON THE DRAWING ARE INTENDED AS A GUIDELINES AND MUST BE VERIFIED DURING LAYOUT. DO NOT SCALE THIS DRAWING.
 - THE CONTRACTOR IS RESPONSIBLE FOR THE COORDINATION OF SERVICES INTO THE WORKS AS MAY BE REQUIRED.
 - PREPARE WORKING DETAILED DRAWING / SHOP DRAWING FOR APPROVAL IF REQUIRED BY CONSULTANT.
 - READ THIS DRAWING IN CONJUNCTION WITH RELEVANT ARCHITECTURAL, STRUCTURAL AND SERVICES DRAWINGS, SPECIFICATIONS, DETAILS AND CONTRACT DOCUMENTS.
 - ANY VARIATION / DISCREPANCIES TO BE HIGHLIGHTED IMMEDIATELY BEFORE COMMENCING ANY WORK.

06/01/2025	FIRST UPLOAD	R0
DATE	DESCRIPTION	REV

CONCEPTUAL DRAWING			
REFERENCE DRAWING	DRAWING NO.	DATE	REV
ARCHITECTURAL	---	---	-
STRUCTURAL	---	---	-
PROJECT:	PANSARI DEVELOPERS LTD RESIDENTIAL GOPALPUR PROJECT AT KOLKATA.		
OWNER:	PANSARI DEVELOPERS LIMITED KOLKATA.		
STRUCTURAL:	ADROIT CONSULTANTS KOLKATA		
ARCHITECT:	MAHESHSWARI ASSOCIATE		

MEP CONSULTANT

s n joshi consultants pvt ltd
5th Floor, The Metropolitan,
Shivajinagar,
Pune 411005
Tel : 99755 71105
web - www.snjoshiconsultants.com

PROJECT NO.	4165		
TITLE:	EXTERNAL WATER SUPPLY LAYOUT		
BLDG. #	DRAWING NUMBER	REV. NO.	
--	4165-CON-PHE-00-EXTL-WSL	R0	
DATE	SCALE	DRAWN	CHECKED
06/01/2025	1:100	DEEPAK H.	MANISH N.