






A FRONT SIDE ELEVATION
SCALE: 1:100

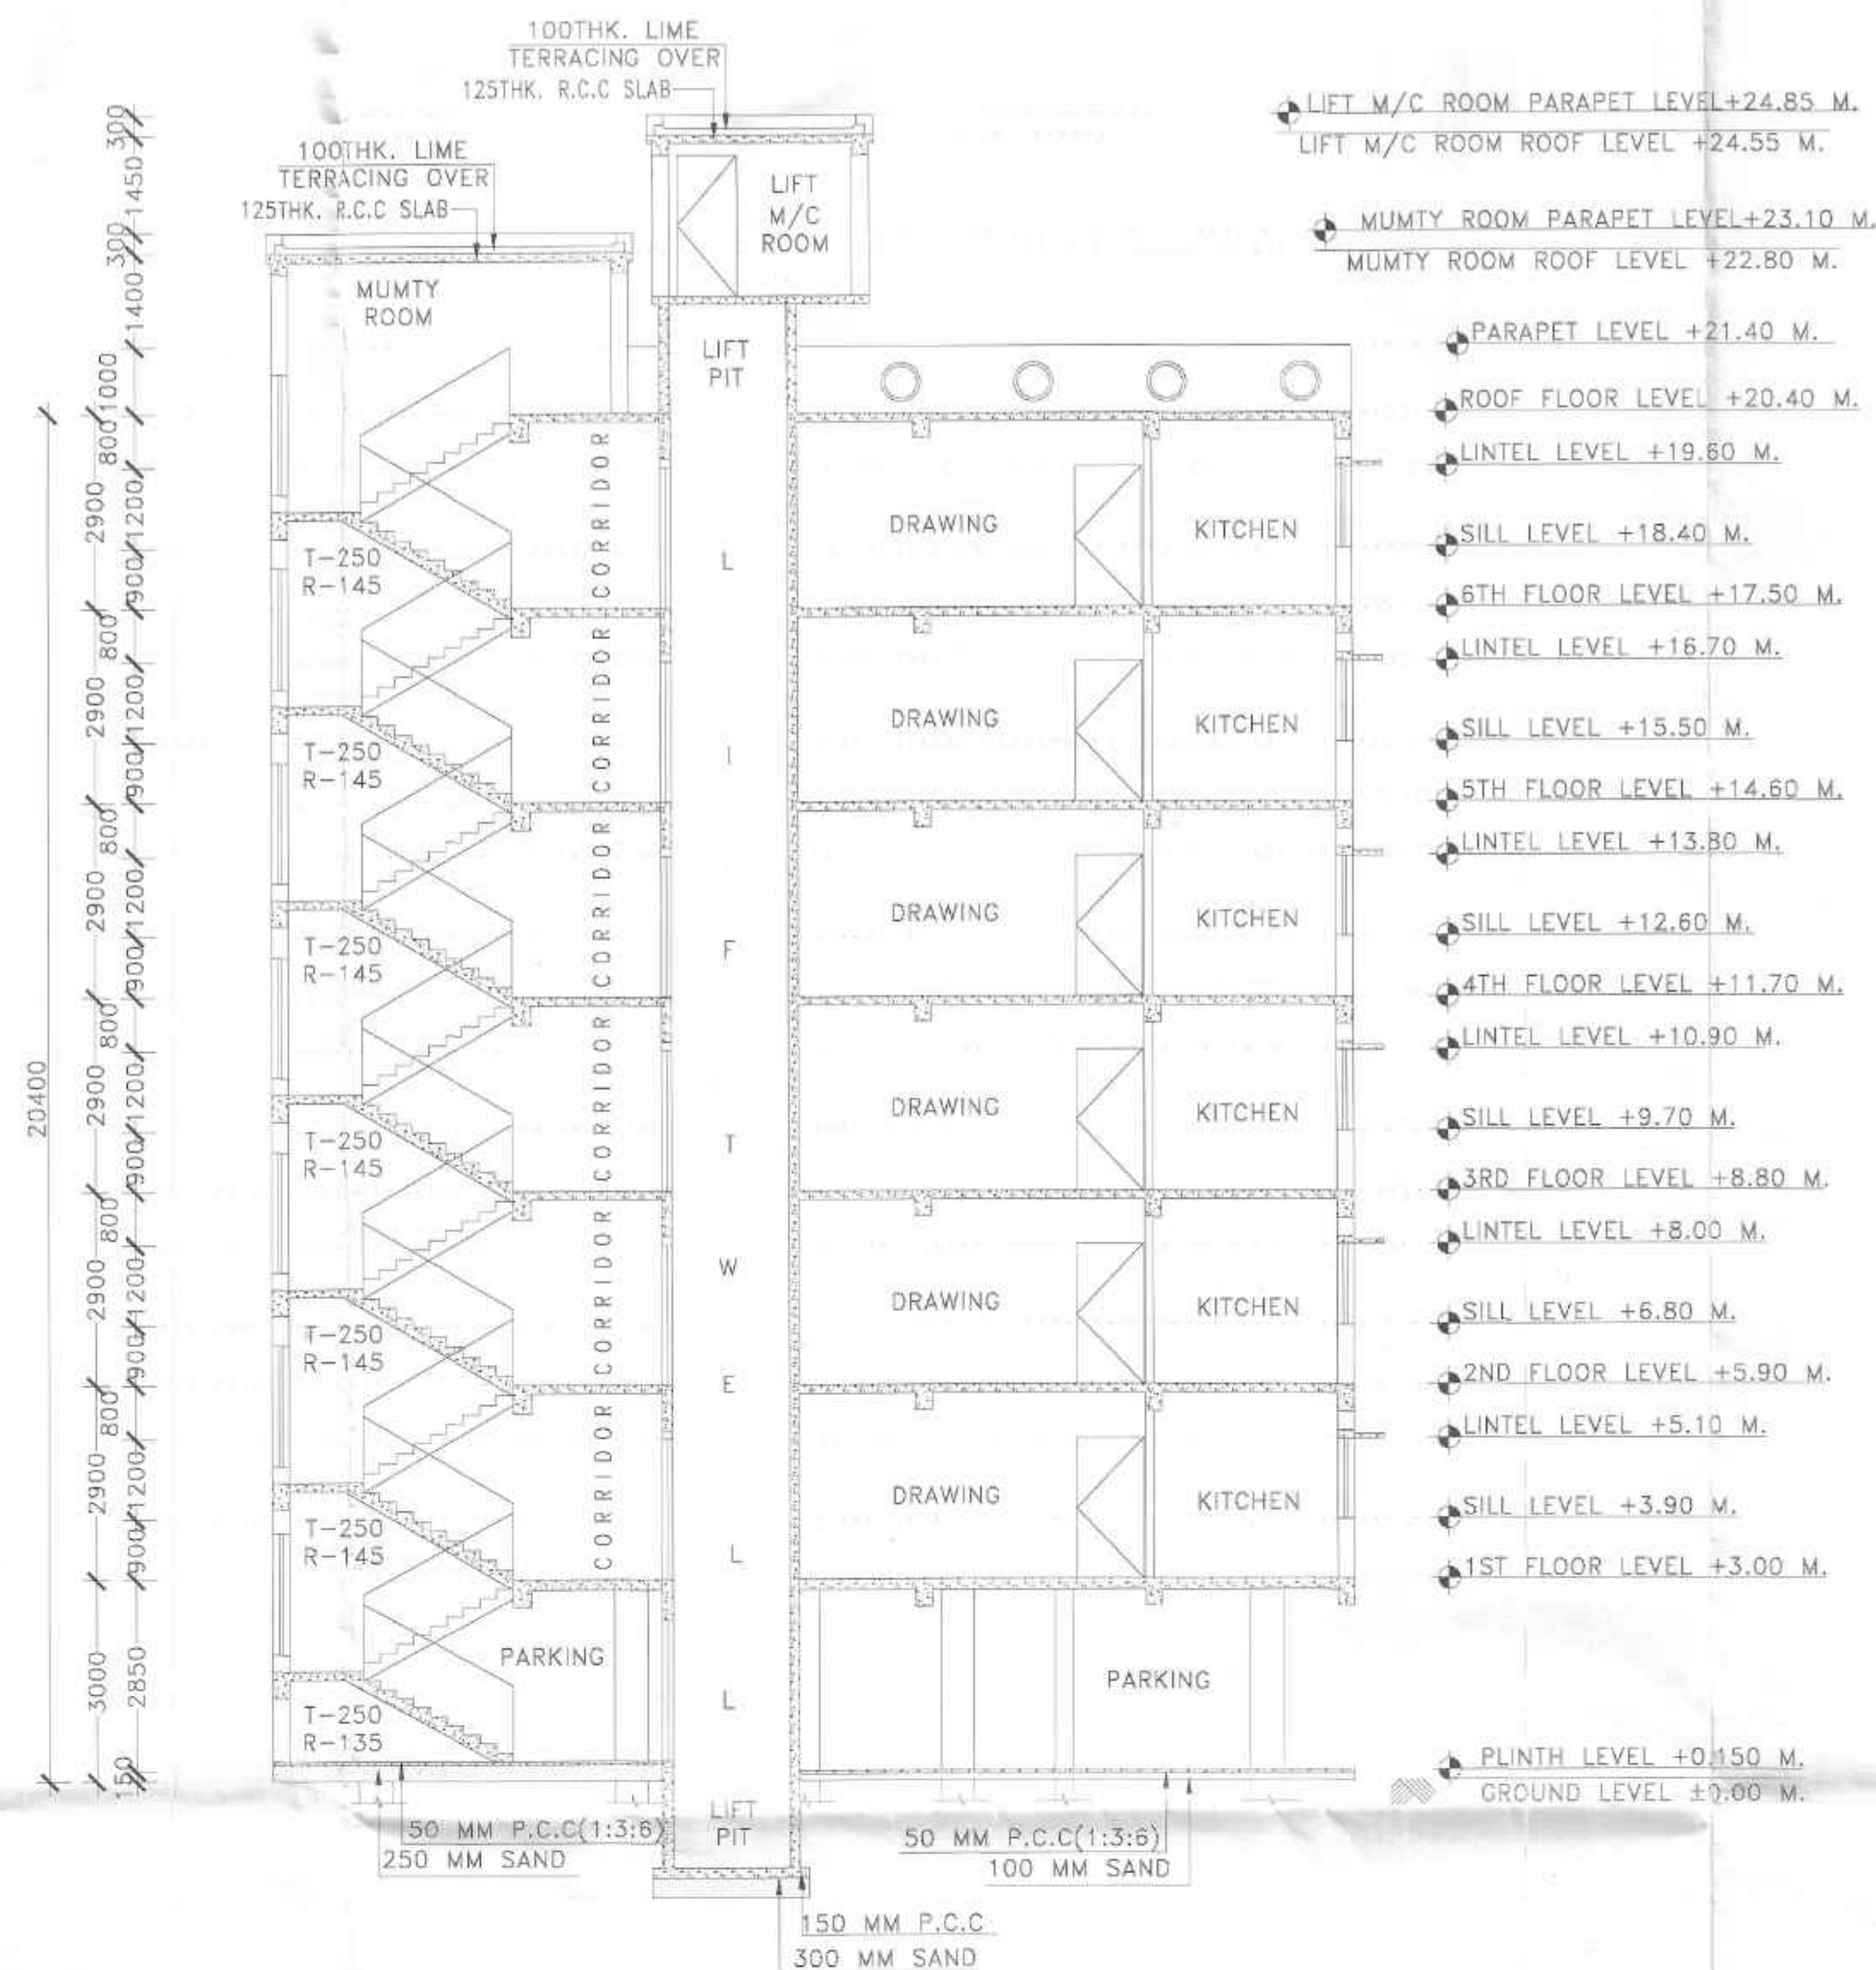


SECTION: -X-X
SCALE: 1:100

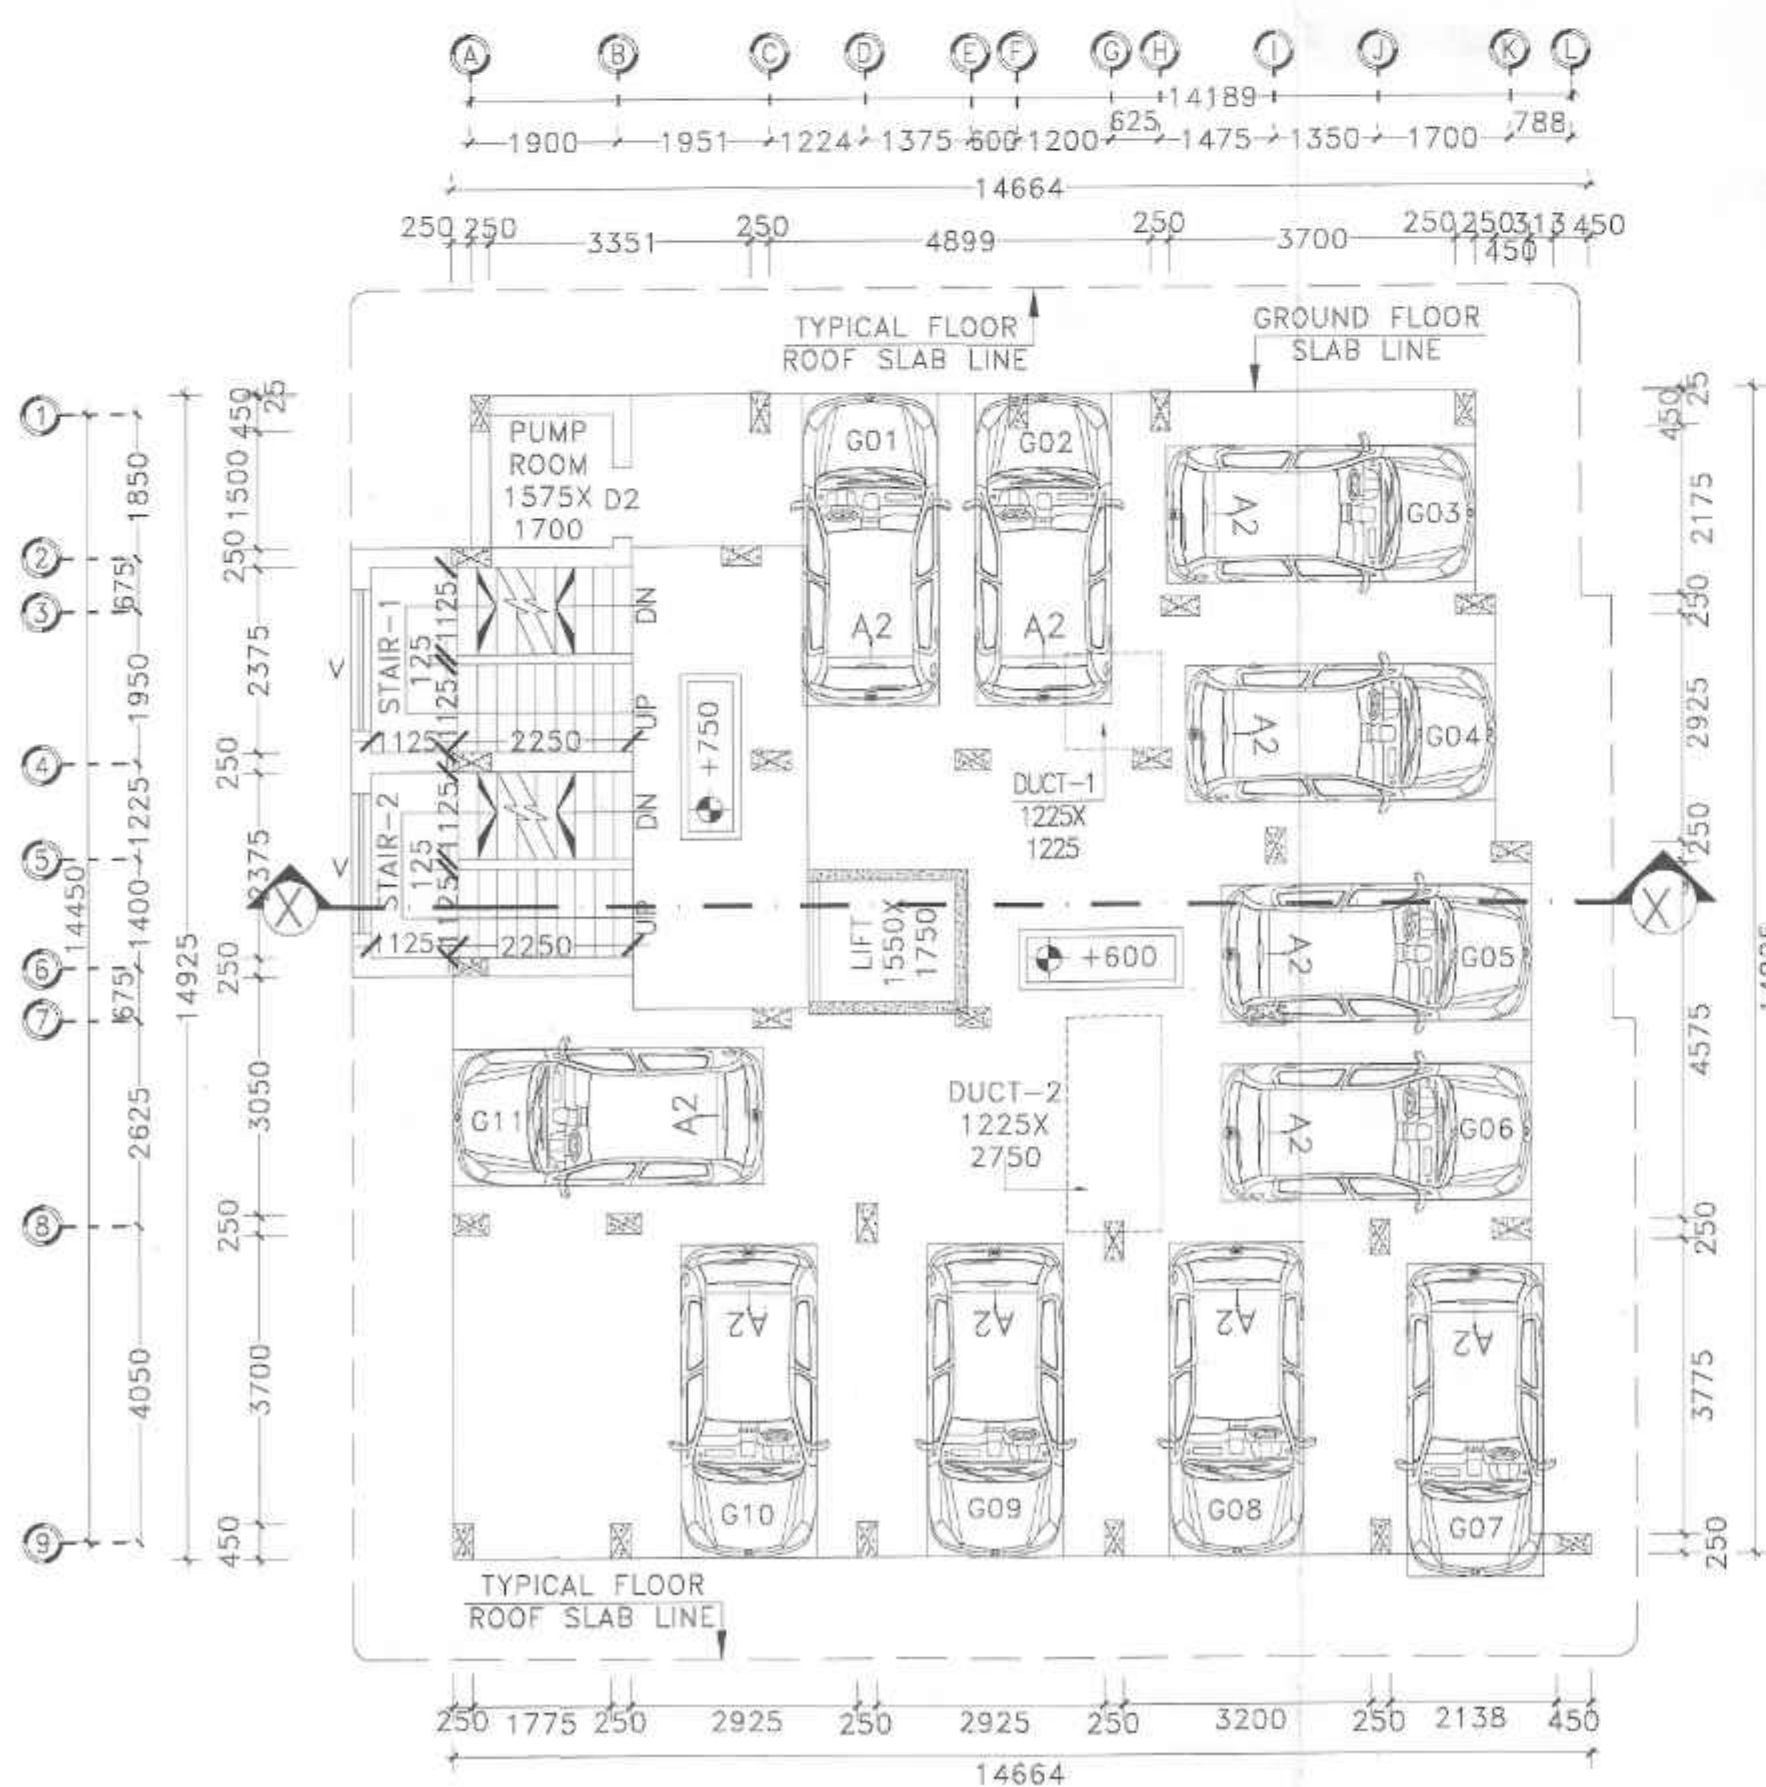

© GROUND FLOOR PLAN
SCALE: 1:100

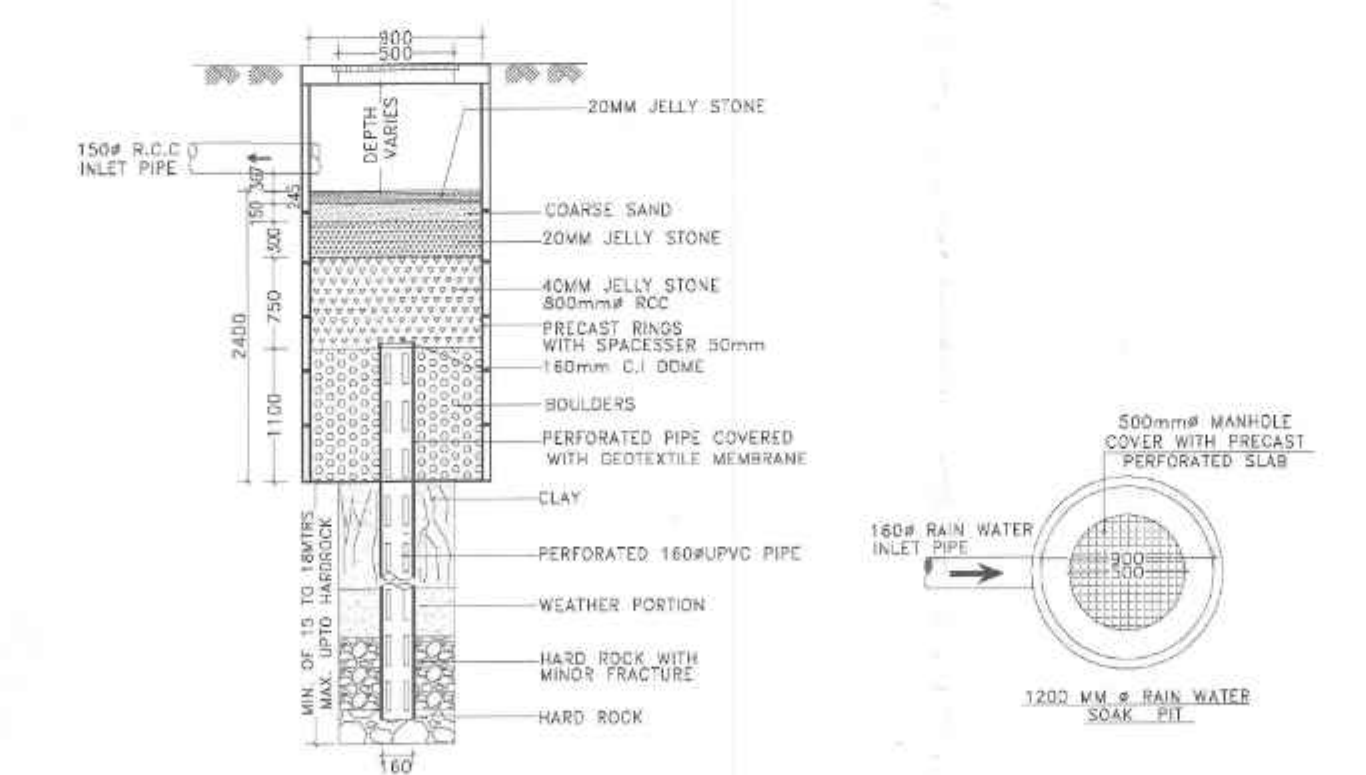

(D) SECTIONAL DETAILS OF RAIN WATER SOAK PIT
SCALE: N.T.S.

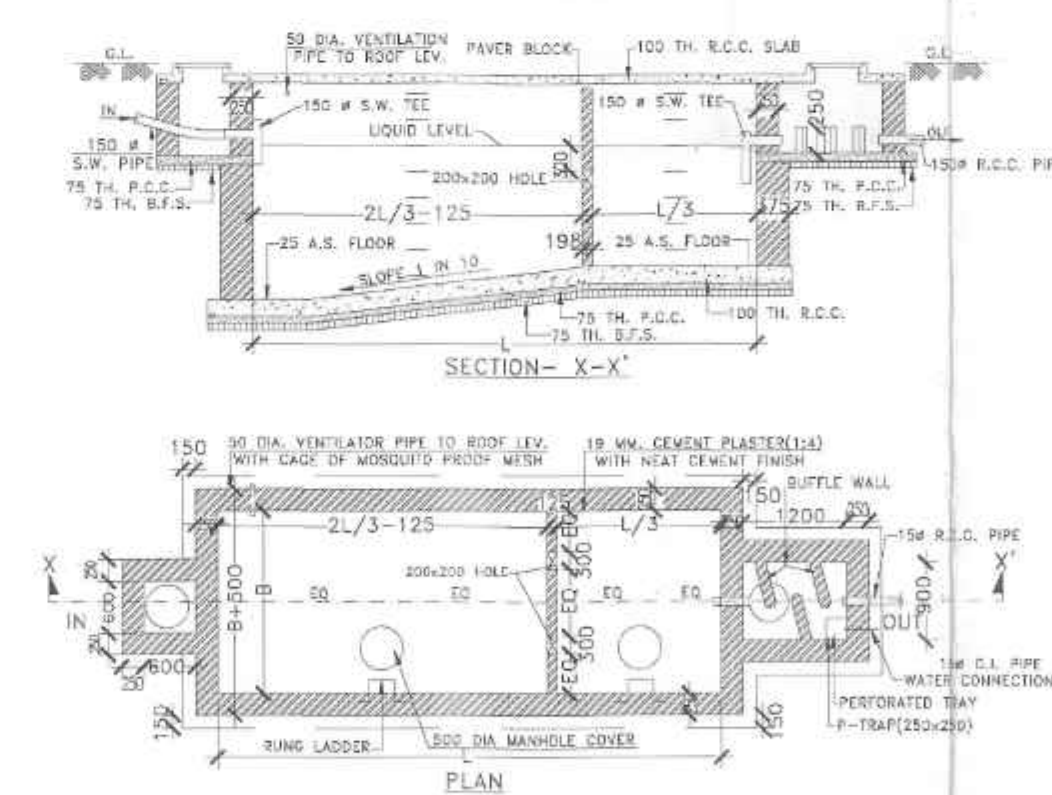

E DETAILS OF SEPTIC TANK
SCALE: N.T.S.

SIGNATURE OF ARCHITECT:—

SIGNATURE OF GEO TECHNICAL ENGINEER:-

SIGNATURE OF STRUCTURAL ENGINEER:-

TITLE:—

MANJU MONOWARA KHATUN
ARCHITECT
CA/2022/146222
GIDS, Durgapur -16

MANDU MALTY
Civil / Geotechnical Engineer
CE, MIGS-LM4278
Lic. No. -LBPM/162/AMC
G.I.D.S., Durgapur-16

17-5-4 Chh
HIROK GHOSH
Structural Engineer
LIC No. L.B.P.M/163/AMC-DMC/BPD/165
DCE, B-TECH, G.I.D.S. Durgapur-16
Contact No.- 7602984157

- * FRONT SIDE ELEVATION
- * SECTIONAL VIEW
- * GROUND FLOOR PLAN
- * SECTIONAL DETAILS OF RAIN WATER SOAK PIT
- * DETAILS OF SEPTIC TANK

DRAWN BY: S.PANJA.

CHECKED BY: M.KHATUN

SCALE: 1:100, N.T.S.

DATE:-26.08.2023

SHEET NO:- ARCH./P&RD-01/02

