



PROPOSED SANCTION PLAN OF G+IV STORIED RESIDENTIAL
BUILDING OF AJAY AGARWAL AT PREMISES NO.02-0646 PLOT NO
: 2044 AA-IIC OF NEW TOWN, KOLKATA.

SERVICE DRAWING
1) SEWERAGE LINE ,
MASTER PIT, INSEPECTION PIT
SCALE= 1:100

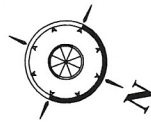

DWG. NO - 02-0646/SCRV./SANC - 03/R-02
REVISION OF - 01@31.03.2023
DATE - 06.04.2023

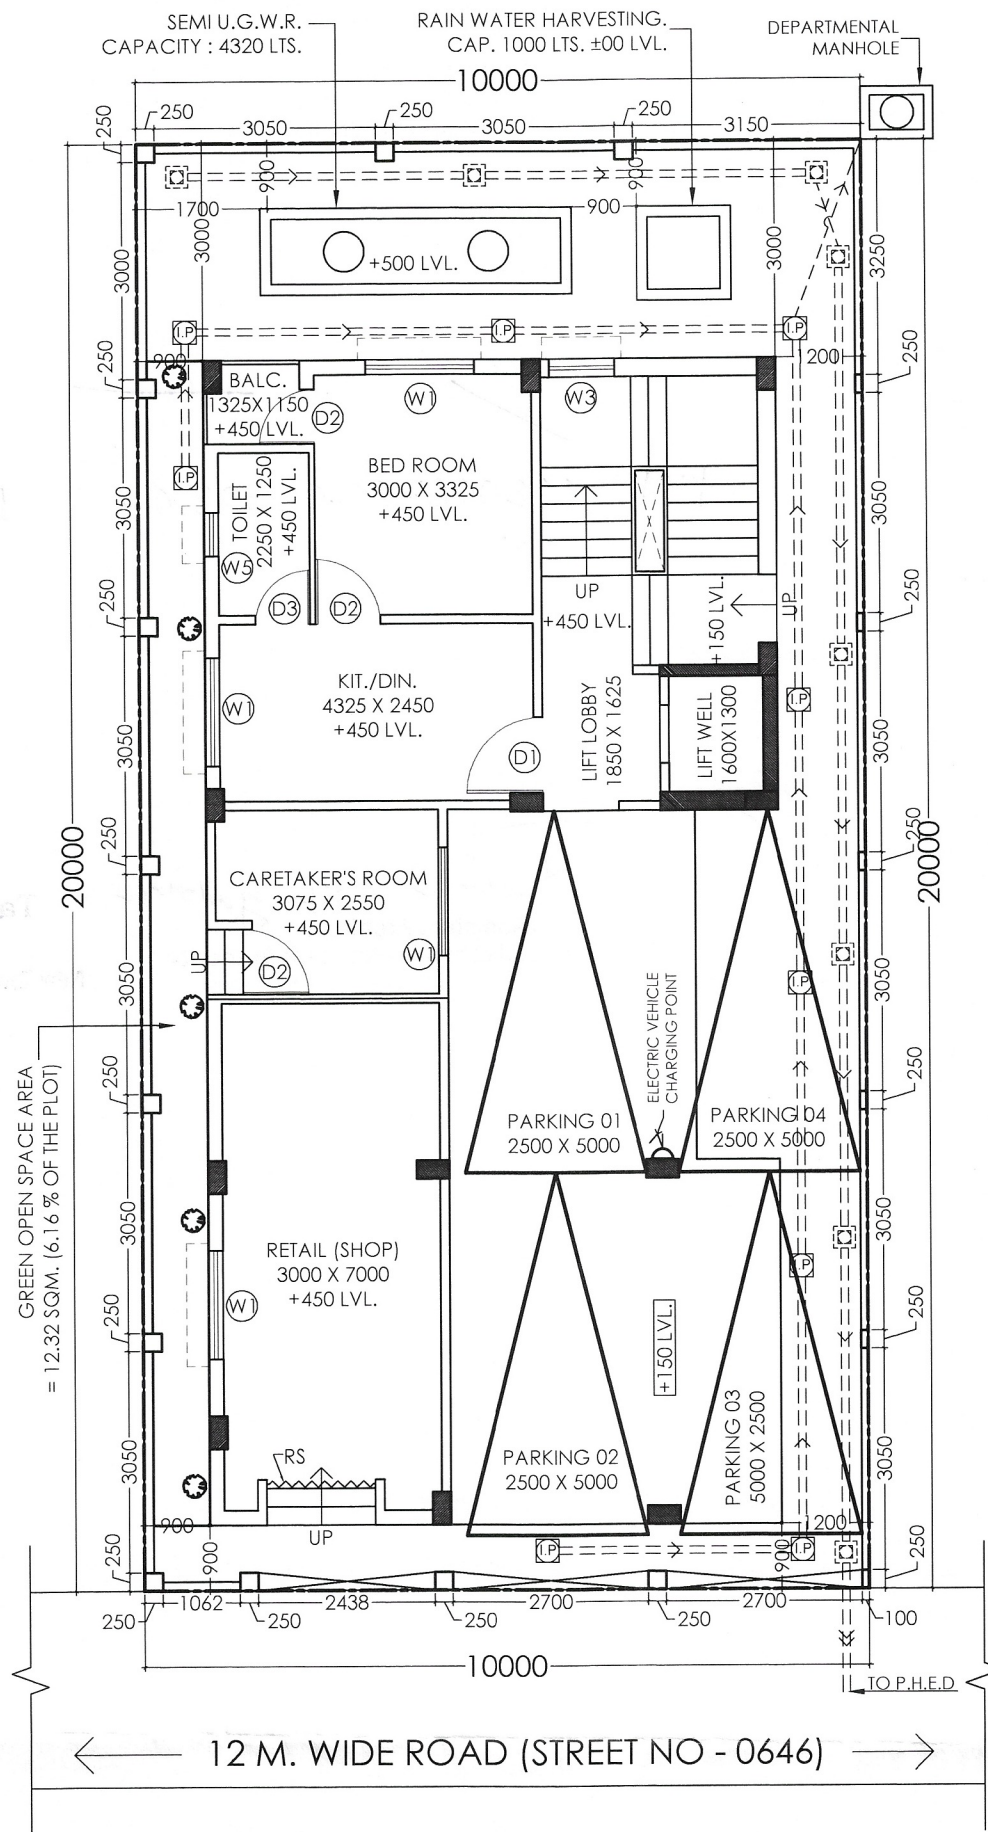

ON SITE GROUND FLOOR PLAN
SCALE = 1:100

NAME & ENROLMENT NO. OF CIVIL ENGINEER:

Shantanu Das
SHANTANU DAS
Enrollment No: CVER/NKDA/20/00005

NAME & ENROLMENT NO. OF ARCHITECT:

THE POSITION OF DEPARTMENTAL MANHOLE HAS BEEN CERTIFIED
BY ME ON VERIFICATION

SouGata Dhara
SOUGATA DHARA
Enrollment No.: -ACHR/NKDA/10/00211

NAME & COMMUNICATION ADDRESS OF APPLICANT:

As Constituted Attorney of
AJAY AGARWAL SK NGLN

AJAY AGARWAL
ADDRESS:
S/O :LAKSHMENDRA KUMAR AGARWAL,
DA-122,SECTOR-1,SALT LAKE,DIST.-
NORTH 24 PARGANAS, WEST BENGAL,PIN.-700064

PARTY'S COPY

- 1) Permitted to make Connection to the plot/bulk departmental manhole provided for the plot above the invert level in the manhole.
- 2) Permitted to make Connection from the plot to adjacent department storm drain above the invert level in the drain.
- 3) Permitted for above Connection are given subject to the condition that all debris should be cleared from all the service lines by the plot holder.

 
NOTE

THIS SANCTION IS ONLY FOR WATER SUPPLY/
SEWERAGE AND DRAINAGE LAYOUT PLAN

PIN:- 0020064620230504

Date:- 30-May-2023


Assistant Architect
New Town Kolkata Development Authority


Tapan Kumar Dwari
Chief Architect
New Town Kolkata Development Authority