

SCHEDULE OF DOORS & WINDOWS			
TYPE	STL	UNITS	SIZE
D1	2250	760X250	M
D2	2250	900X250 (678)	M
D3	2250	1100X250	M
D4	2250	1300X250	M
D5	2250	1500X250	M
D6	2250	1750X250	M
S01	2250	1800X250	M
S02	2250	1800X250	M
S03	2250	1800X250	M
S04	2250	1800X250	M
S05	2250	1800X250	M
S06	2250	1800X250	M
S07	2250	1800X250	M

1. WE DO NOT ENGAGE ANY FULL RESPONSIBILITY THAT WE SHALL ENGAGE ARCHITECT, E.E.E. & L.T. DESIGN CONSTRUCTION.
2. WE SHALL FOLLOW THE INSTRUCTION OF ARCHITECT, E.E. & L.T. DOING
3. K.M.C AUTHORITY WILL BE RESPONSIBLE FOR DISTRIBUTION, STABILITY OF
4. THE BUILDING, A JOINTING STRUCTURE.
5. K.M.C AUTHORITY WILL BE FOUND TO BE ONE, THE K.M.C. AUTHORITY
6. K.M.C AUTHORITY WILL BE FOUND TO BE ONE, THE K.M.C. AUTHORITY
7. THE CONSTRUCTION OF UNDERGROUND WATER RESERVOIR WILL BE UNDER
8. THE GUIDANCE OF ARCHITECT, E.E. & L.T. BEFORE STARTING OF BUILDING
9. THE PREMISES IS NOT TREATED, AND PLANT OUPUT BY THE OWNERS
10. DURING INSPECTION OF THE LOT WAS IDENTIFIED BY US.
11. THERE IS NO DATA COULD CASE REMAIN AGAIN THIS PREMISES
12. EXISTING IS FOUND TO BE THE PROPOSED BEFORE COMMENCEMENT OF WORK.

SSI TRADING DALLAS, CA, OF:
1. SSI TRADING DALLAS, CA, PRIVATE LIMITED
2. SSMARIN, EXPORTS PRIVATE LIMITED
3. JAGMATA INFOTECH LLP
4. SHIVACHALISA INFOTECH LLP
5. YANAKA SIKHA CONSTRUCTION LLP
6. YANAKA SIKHA CONSTRUCTION LLP
7. WHITE SOURCE PROPERTIES PVT. LTD.

DECLARATION OF STRUCTURAL ENGINEER

THE STRUCTURAL DESIGN AND DRAWINGS OF BOTH FOUNDATION AND SUPERSTRUCTURE OF THE BUILDING HAS BEEN MADE BY ME, CONSIDERING THE SOIL TEST REPORT AS PER THESE RULES AND THE REGULATIONS MADE UNDER THE ACT I MADE BY GEOTECH ENGINEERS PVT. LTD., WILKIN ROAD, BALI, MUMBAI 400044, KOLHAPUR-400044, AND ALSO CONSIDERING ALL POSSIBLE LOADS INCLUDING THE RESIDING LOAD AS PER B.B.C. OF INDIA AND CERTIFY THAT IT IS SAFE AND STABLE IN ALL RESPECTS.

DEBIDAS BISWAS
E.S.E./11/272
TAME OF STRUCTURAL ENGINEER

MANAK MALINDER
E.S.R. 01/192/4
NAME OF STRUCTURAL REINER

DECLARATION OF ARCHITECT

DECLARED WITH FULL RESPONSIBILITY THAT THE BUILDING PLAN HAS BEEN DRAWN UP AS PER PROVISIONS OF K.A.C. BUILDING RULES 2009 AS AMENDED FROM TIME TO TIME & THAT THE SITE LOCATION AS INCLUDING VENTILATION OF THE BUILDING AND CONFORMED WITH THE PLAN, WHICH HAS BEEN MEASURED AND VERIFIED BY ME. IT IS A BUILDABLE SITE AND NOT A TANK OR FILLUP OF TANK. THE LAND WITH EXISTING STRUCTURE ARE DEMARCAED BY BOUNDARY WALL. THE CONSTRUCTION OF UNDERGROUND WATER TANK WILL BE COMPLETED BEFORE STARTING OF BUILDING FOUNDATION WORK.

NAME OF ARCHITECT
SANJAY MANDAL
2812 BALLYGUNGE CIRCULAR ROAD, KOL- 19
C.O.A. REG. NO. CA89822821

THE UNDERSIGNED HAS INSPECTED THE SITE AND CARRIED OUT SOIL INVESTIGATION THERE ON. IT IS CERTIFIED THAT EXISTING SOIL OF THE SITE IS ABLE TO CARRY THE LOAD COMING FROM THE PROPOSED CONSTRUCTION AND THE FOUNDATION SYSTEM PROPOSED HEREIN IS SAFE AND STABLE IN ALL RESPECT FROM THE GEO TECHNICAL POINT OF VIEW.

MT. ALOK ROY
G. T/TH/1
MADE OF GEOTECHNICAL ENGINEER

TITLE:
1ST FLOOR PLAN, TYPICAL FLOOR PLAN
2ND - 6TH 8TH - 10TH 12TH - 14TH &

JO8 NO.	JM/1301
DWG. NO.	JM/1301/CD98/JAR-02
SHEET	S/PEY

ISSUE STATUS	CORPORATION
NOTE: 1. ALL DIMENSIONS ARE TO BE READ NOT TO BE 2. INTERIOR WALLS ARE 200 THK. BRICK AND ALL INTERNAL WALLS ARE 100 THK. BRICK WALL. 3. ALL DIMENSIONS ARE IN MM.	

ARCHITECT

INATE

ARCHITECTS PLANNERS ENGINEERS

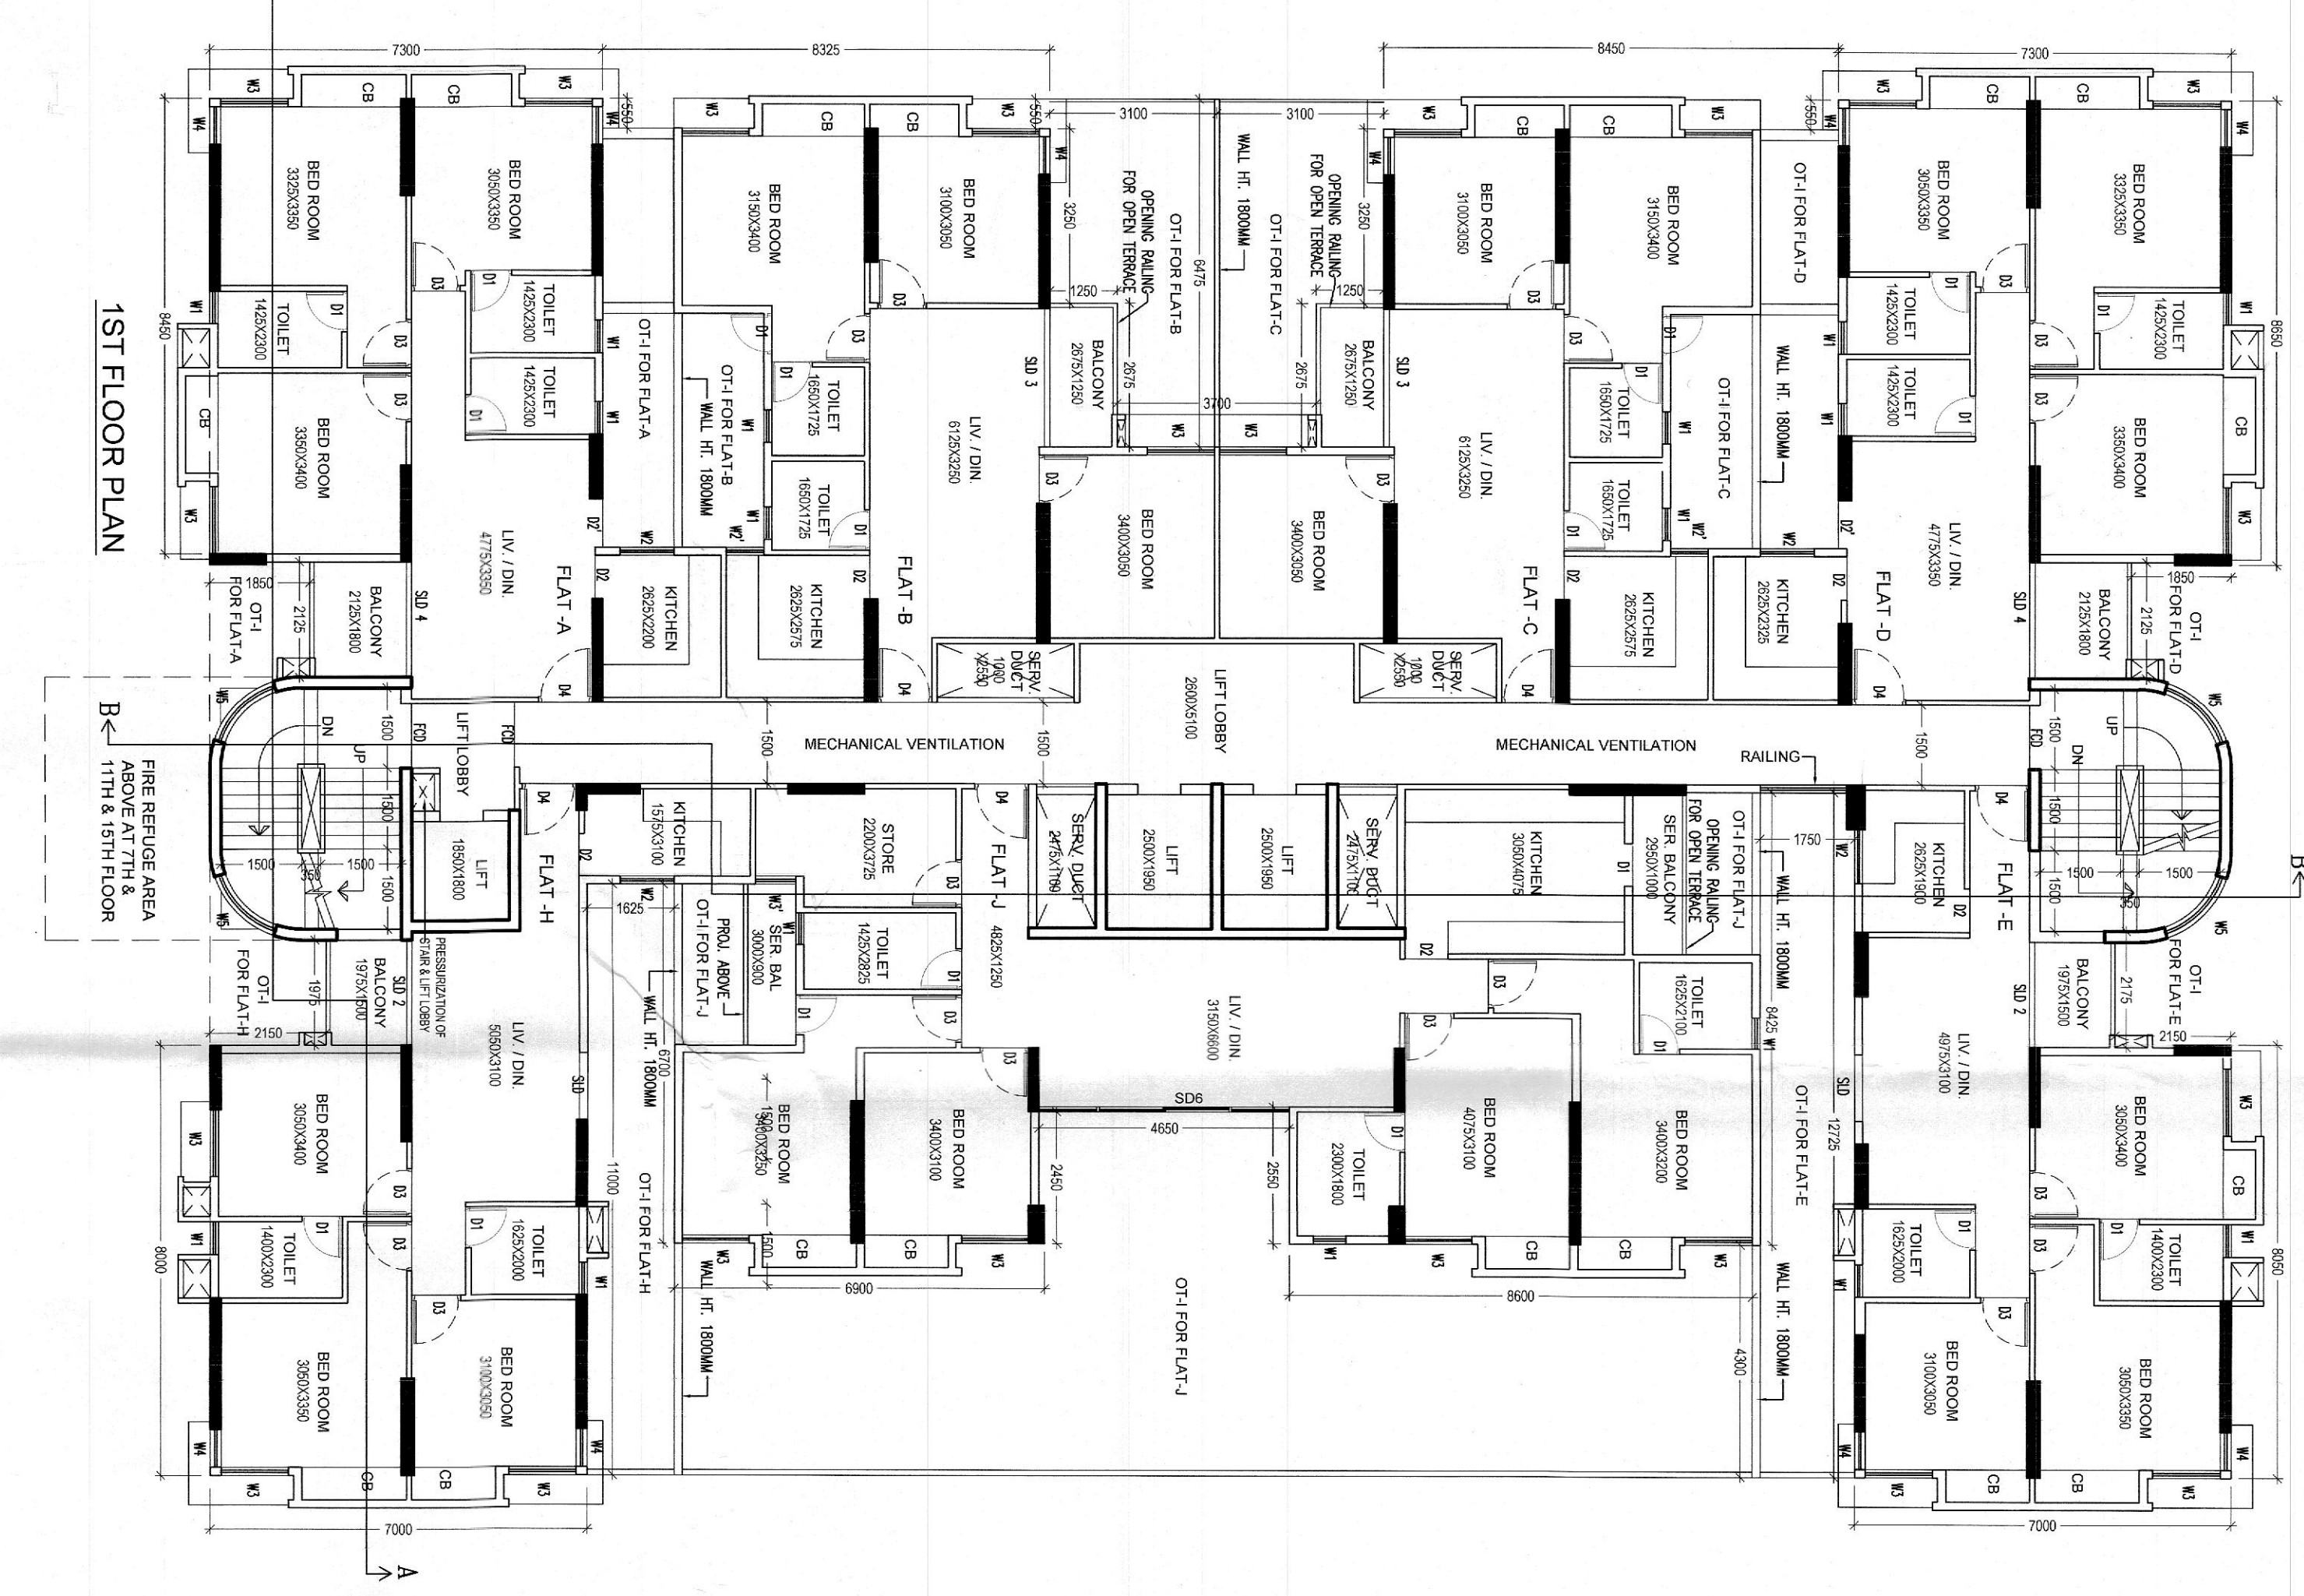
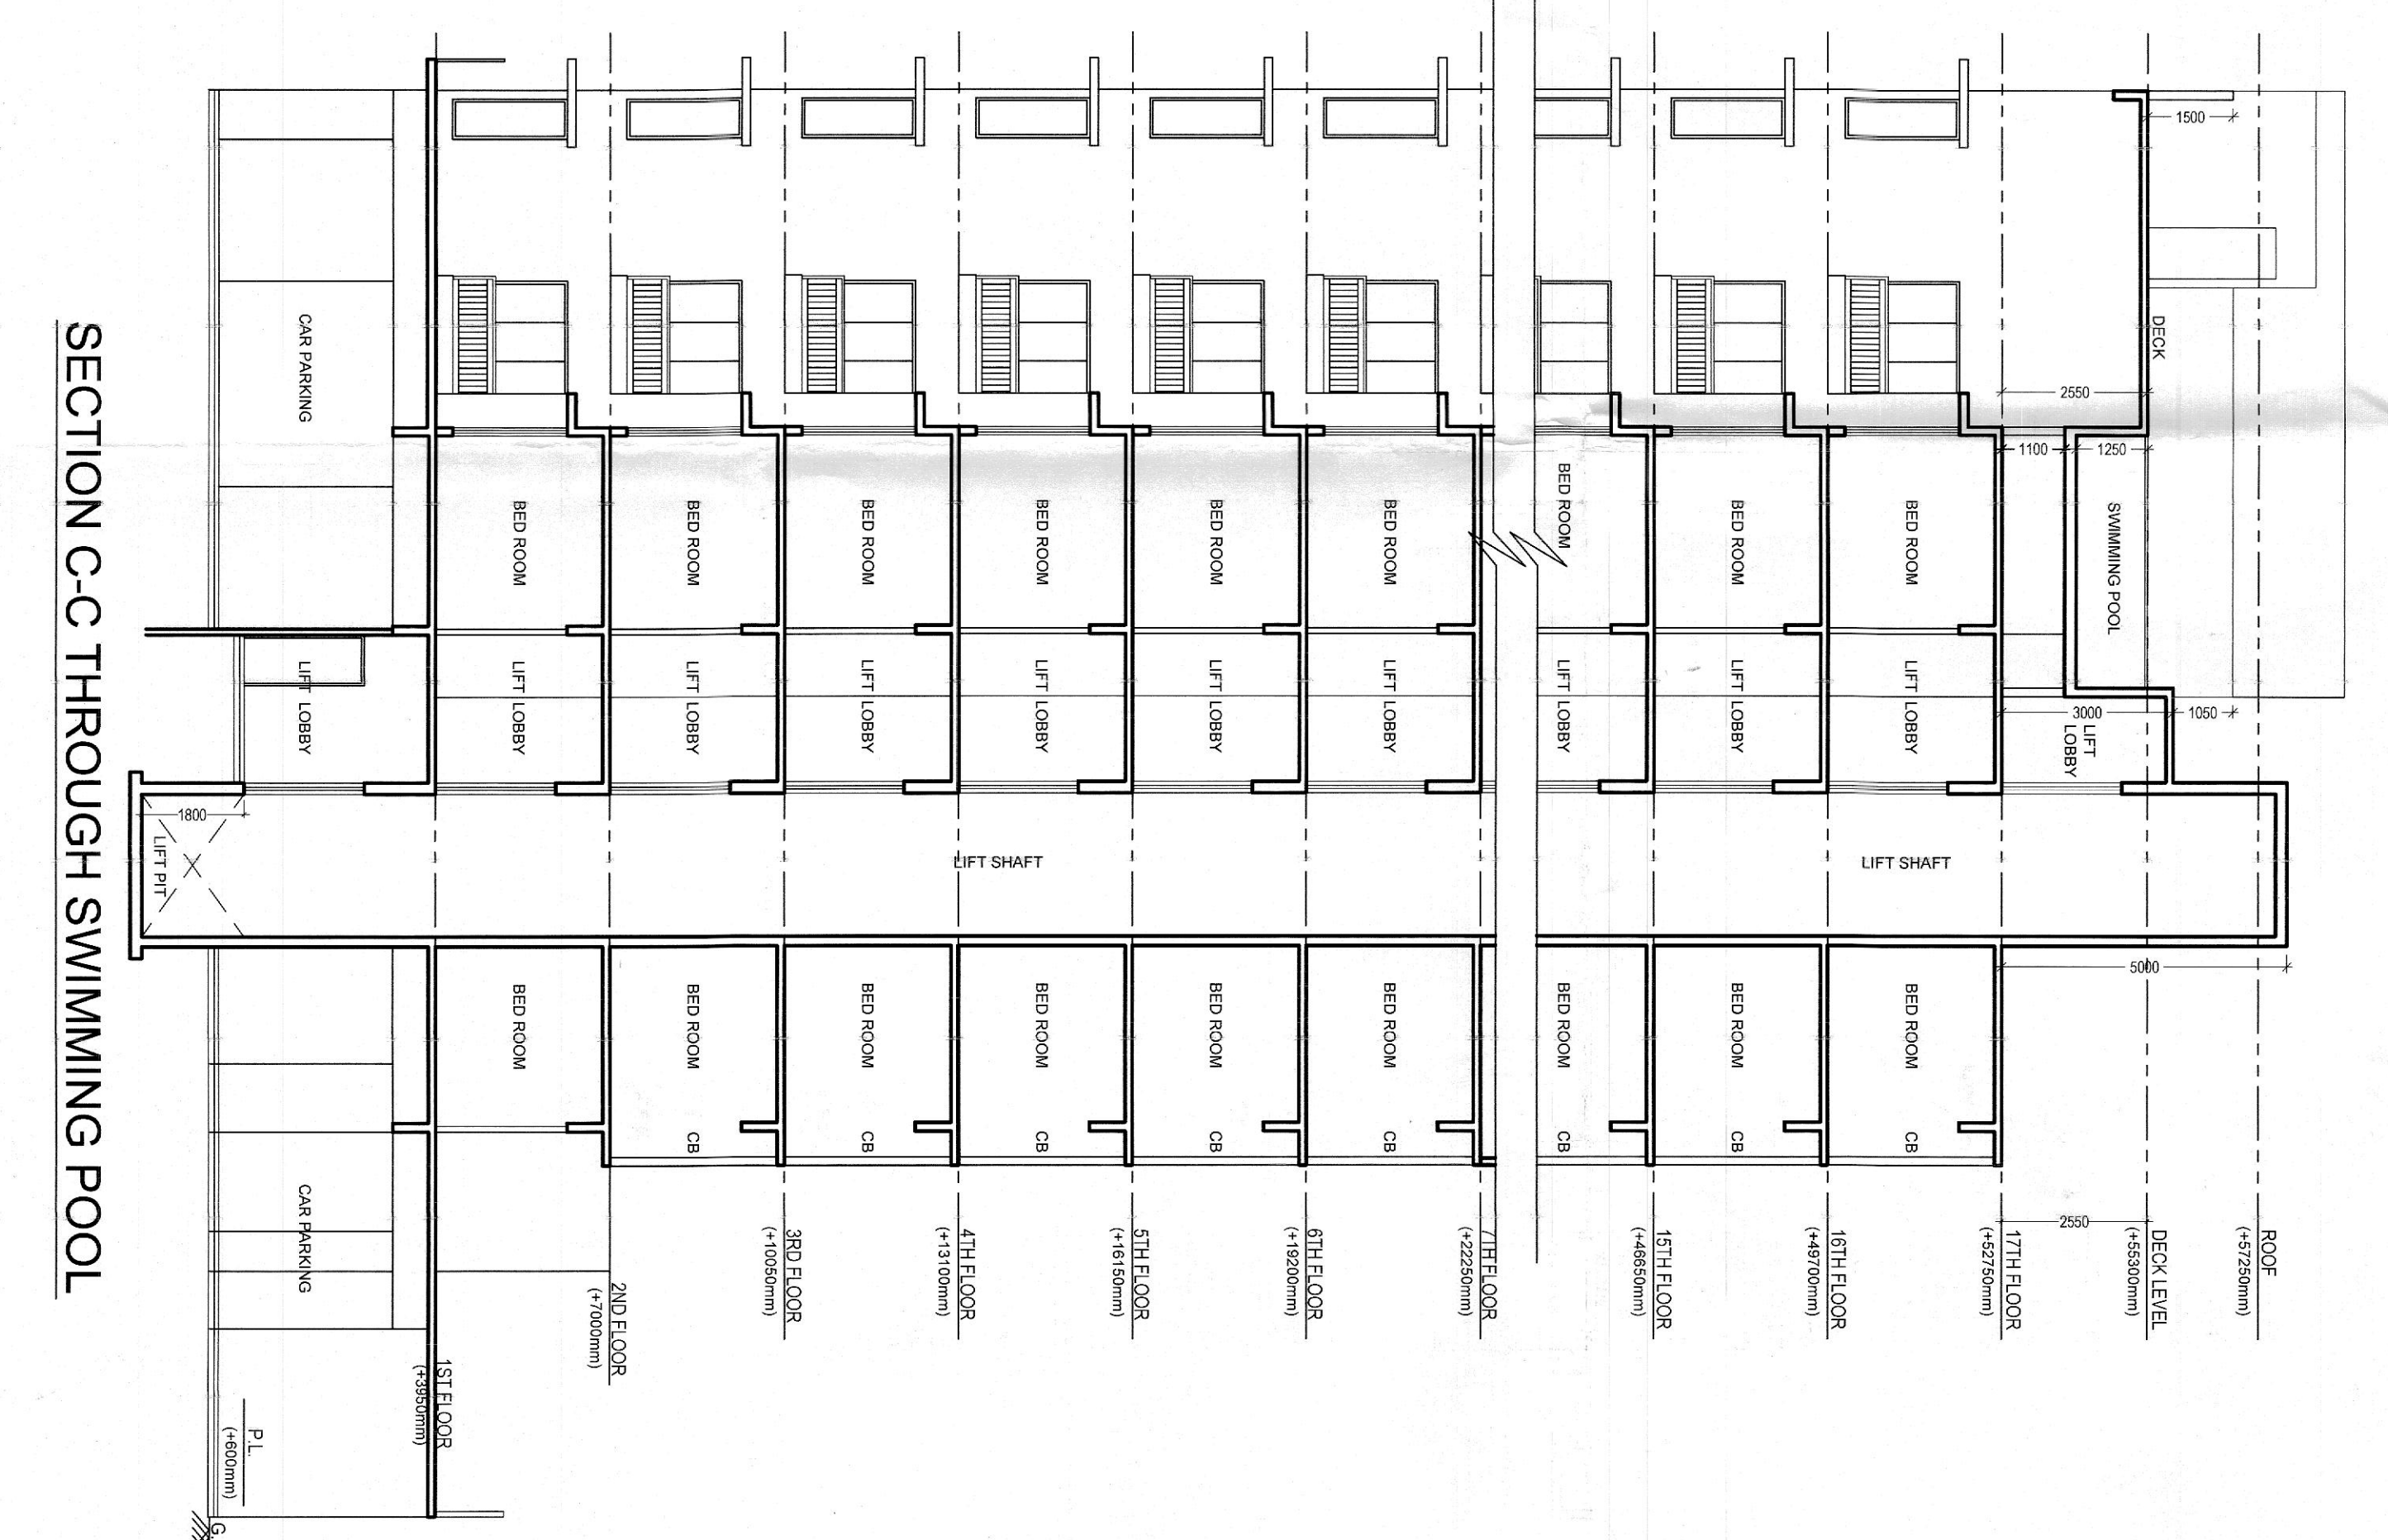
28/2 Ballynoge Circular Road,
3rd Floor, Kildara-00019
TEL: (0133) 4000-842-26
FAX: (0133) 2288-4026
www.inate.ie.com

THIS DRAWING IS A PRIVATE AND CONFIDENTIAL DOCUMENT AND IT MUST NOT TO BE COPIED OR LEFT WITHOUT THE CONSENT OF M/S INMATE

PROJECT

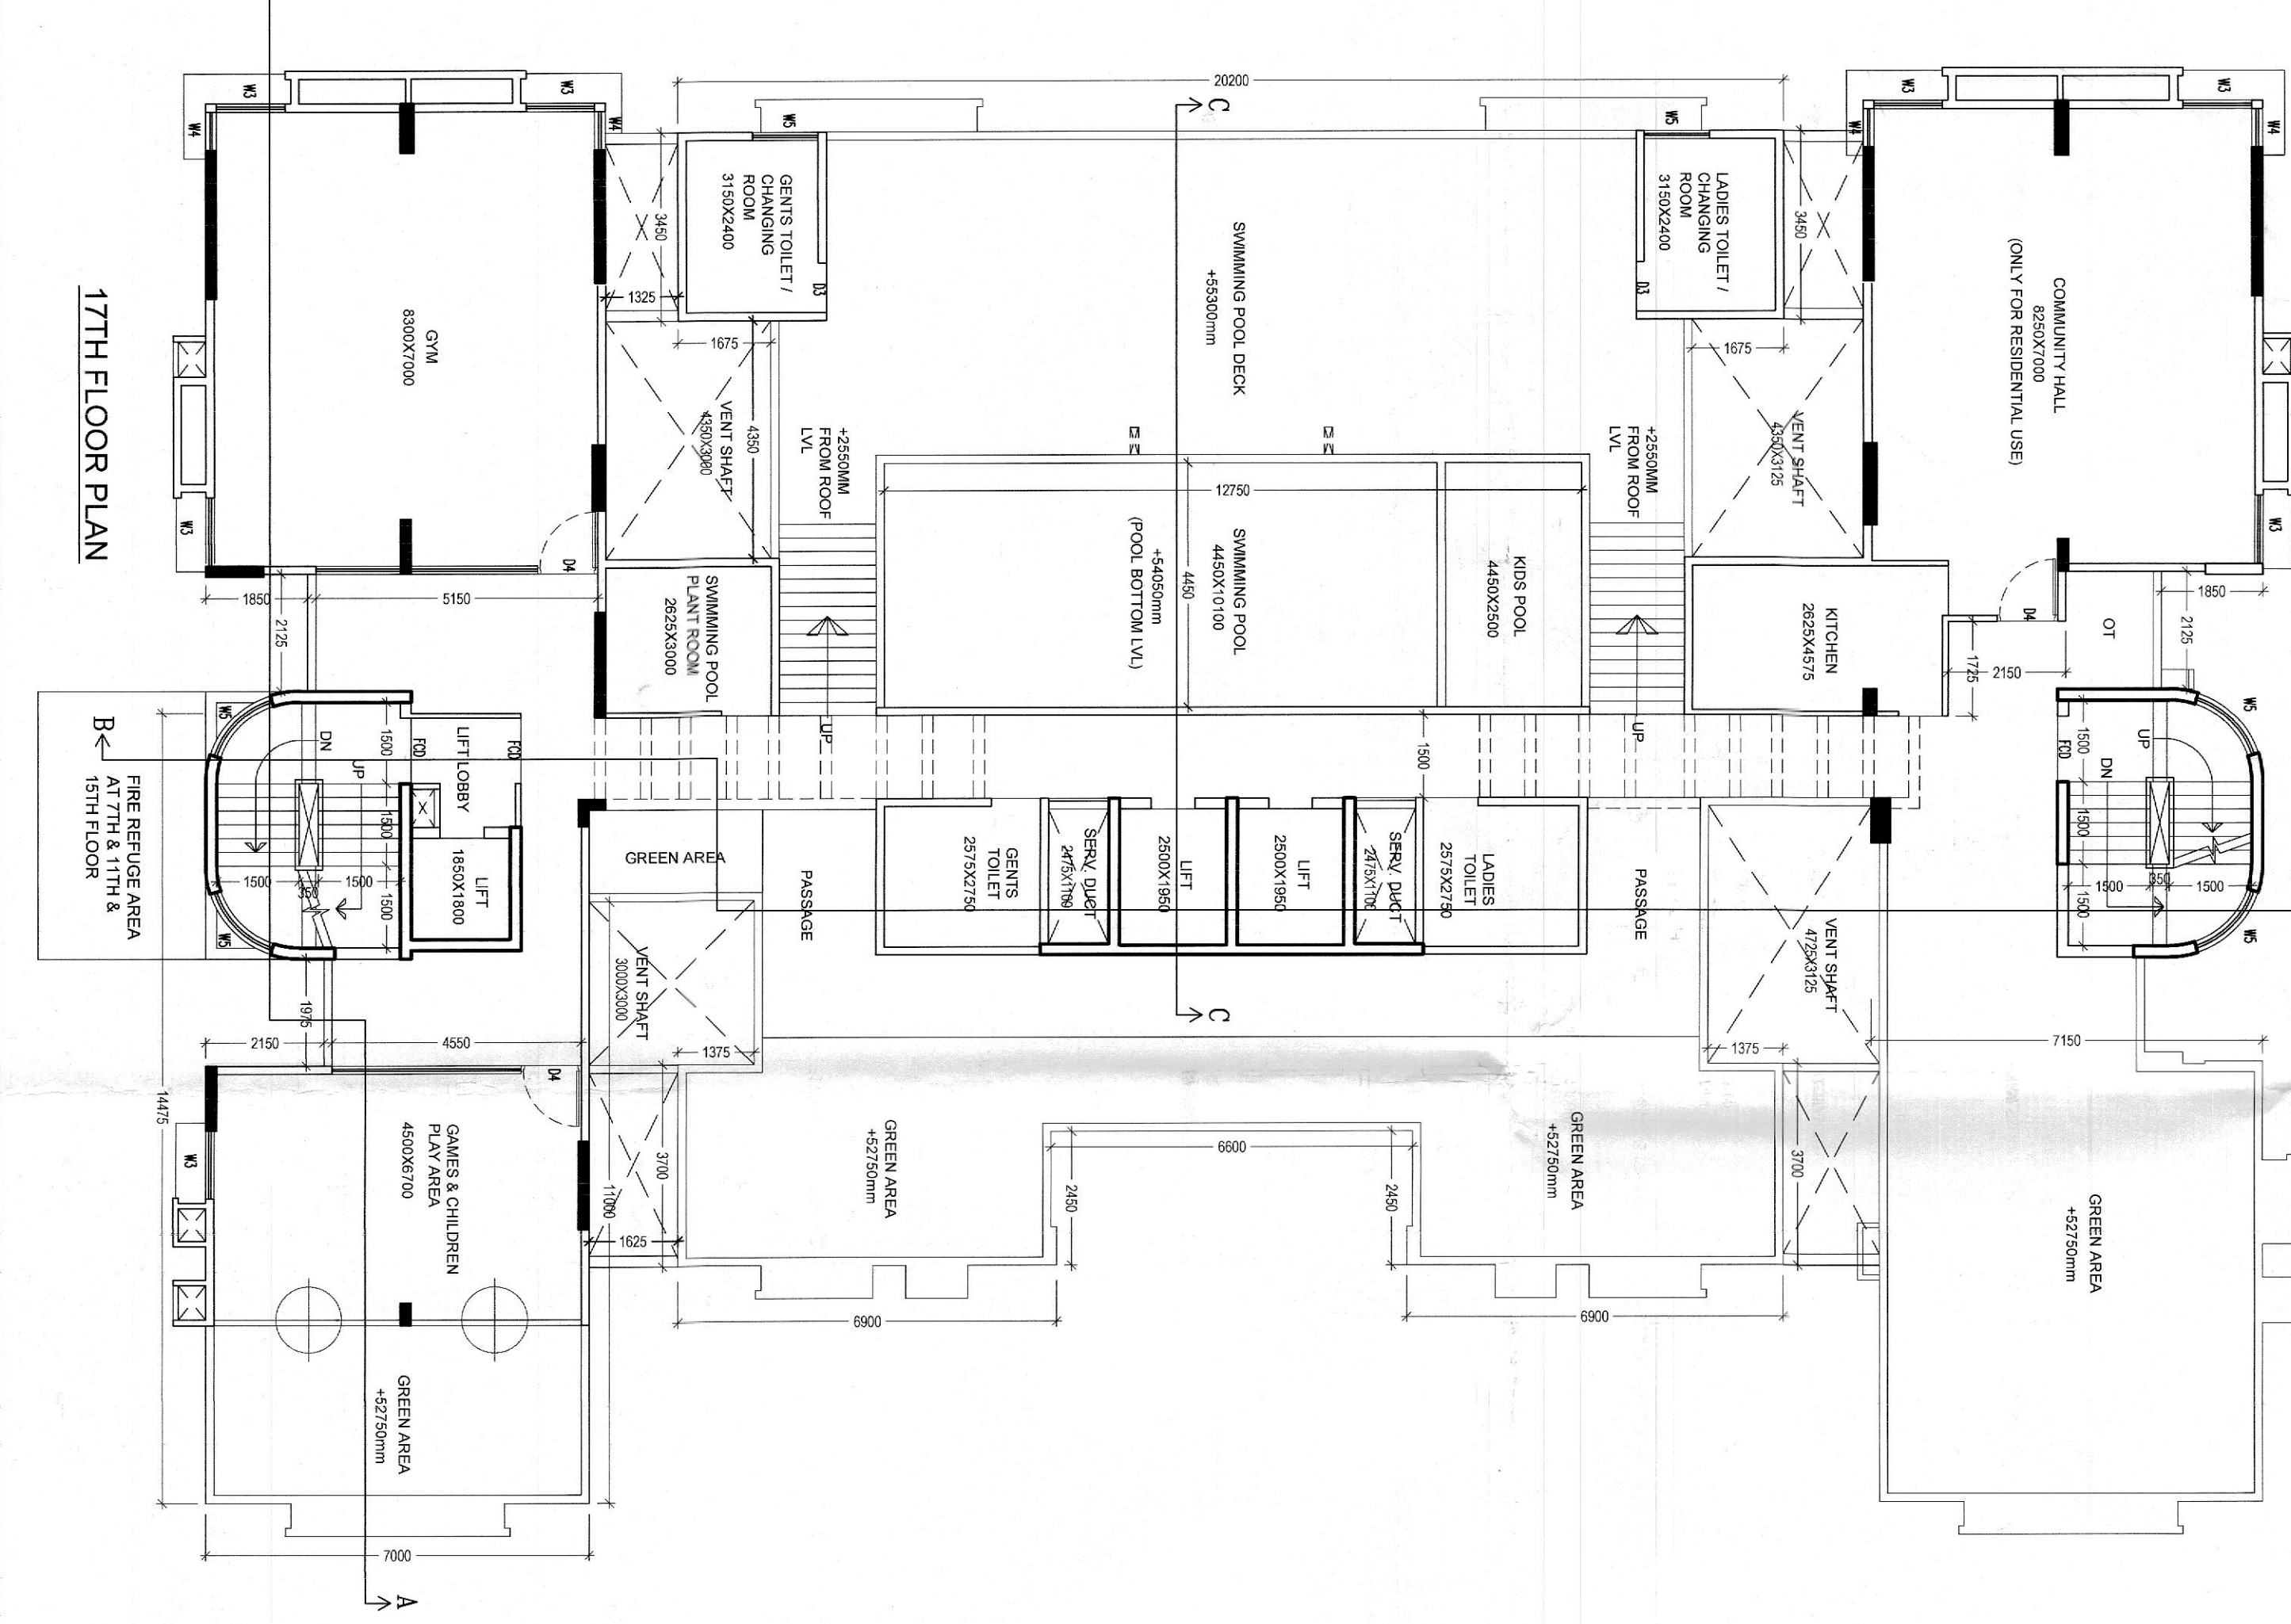
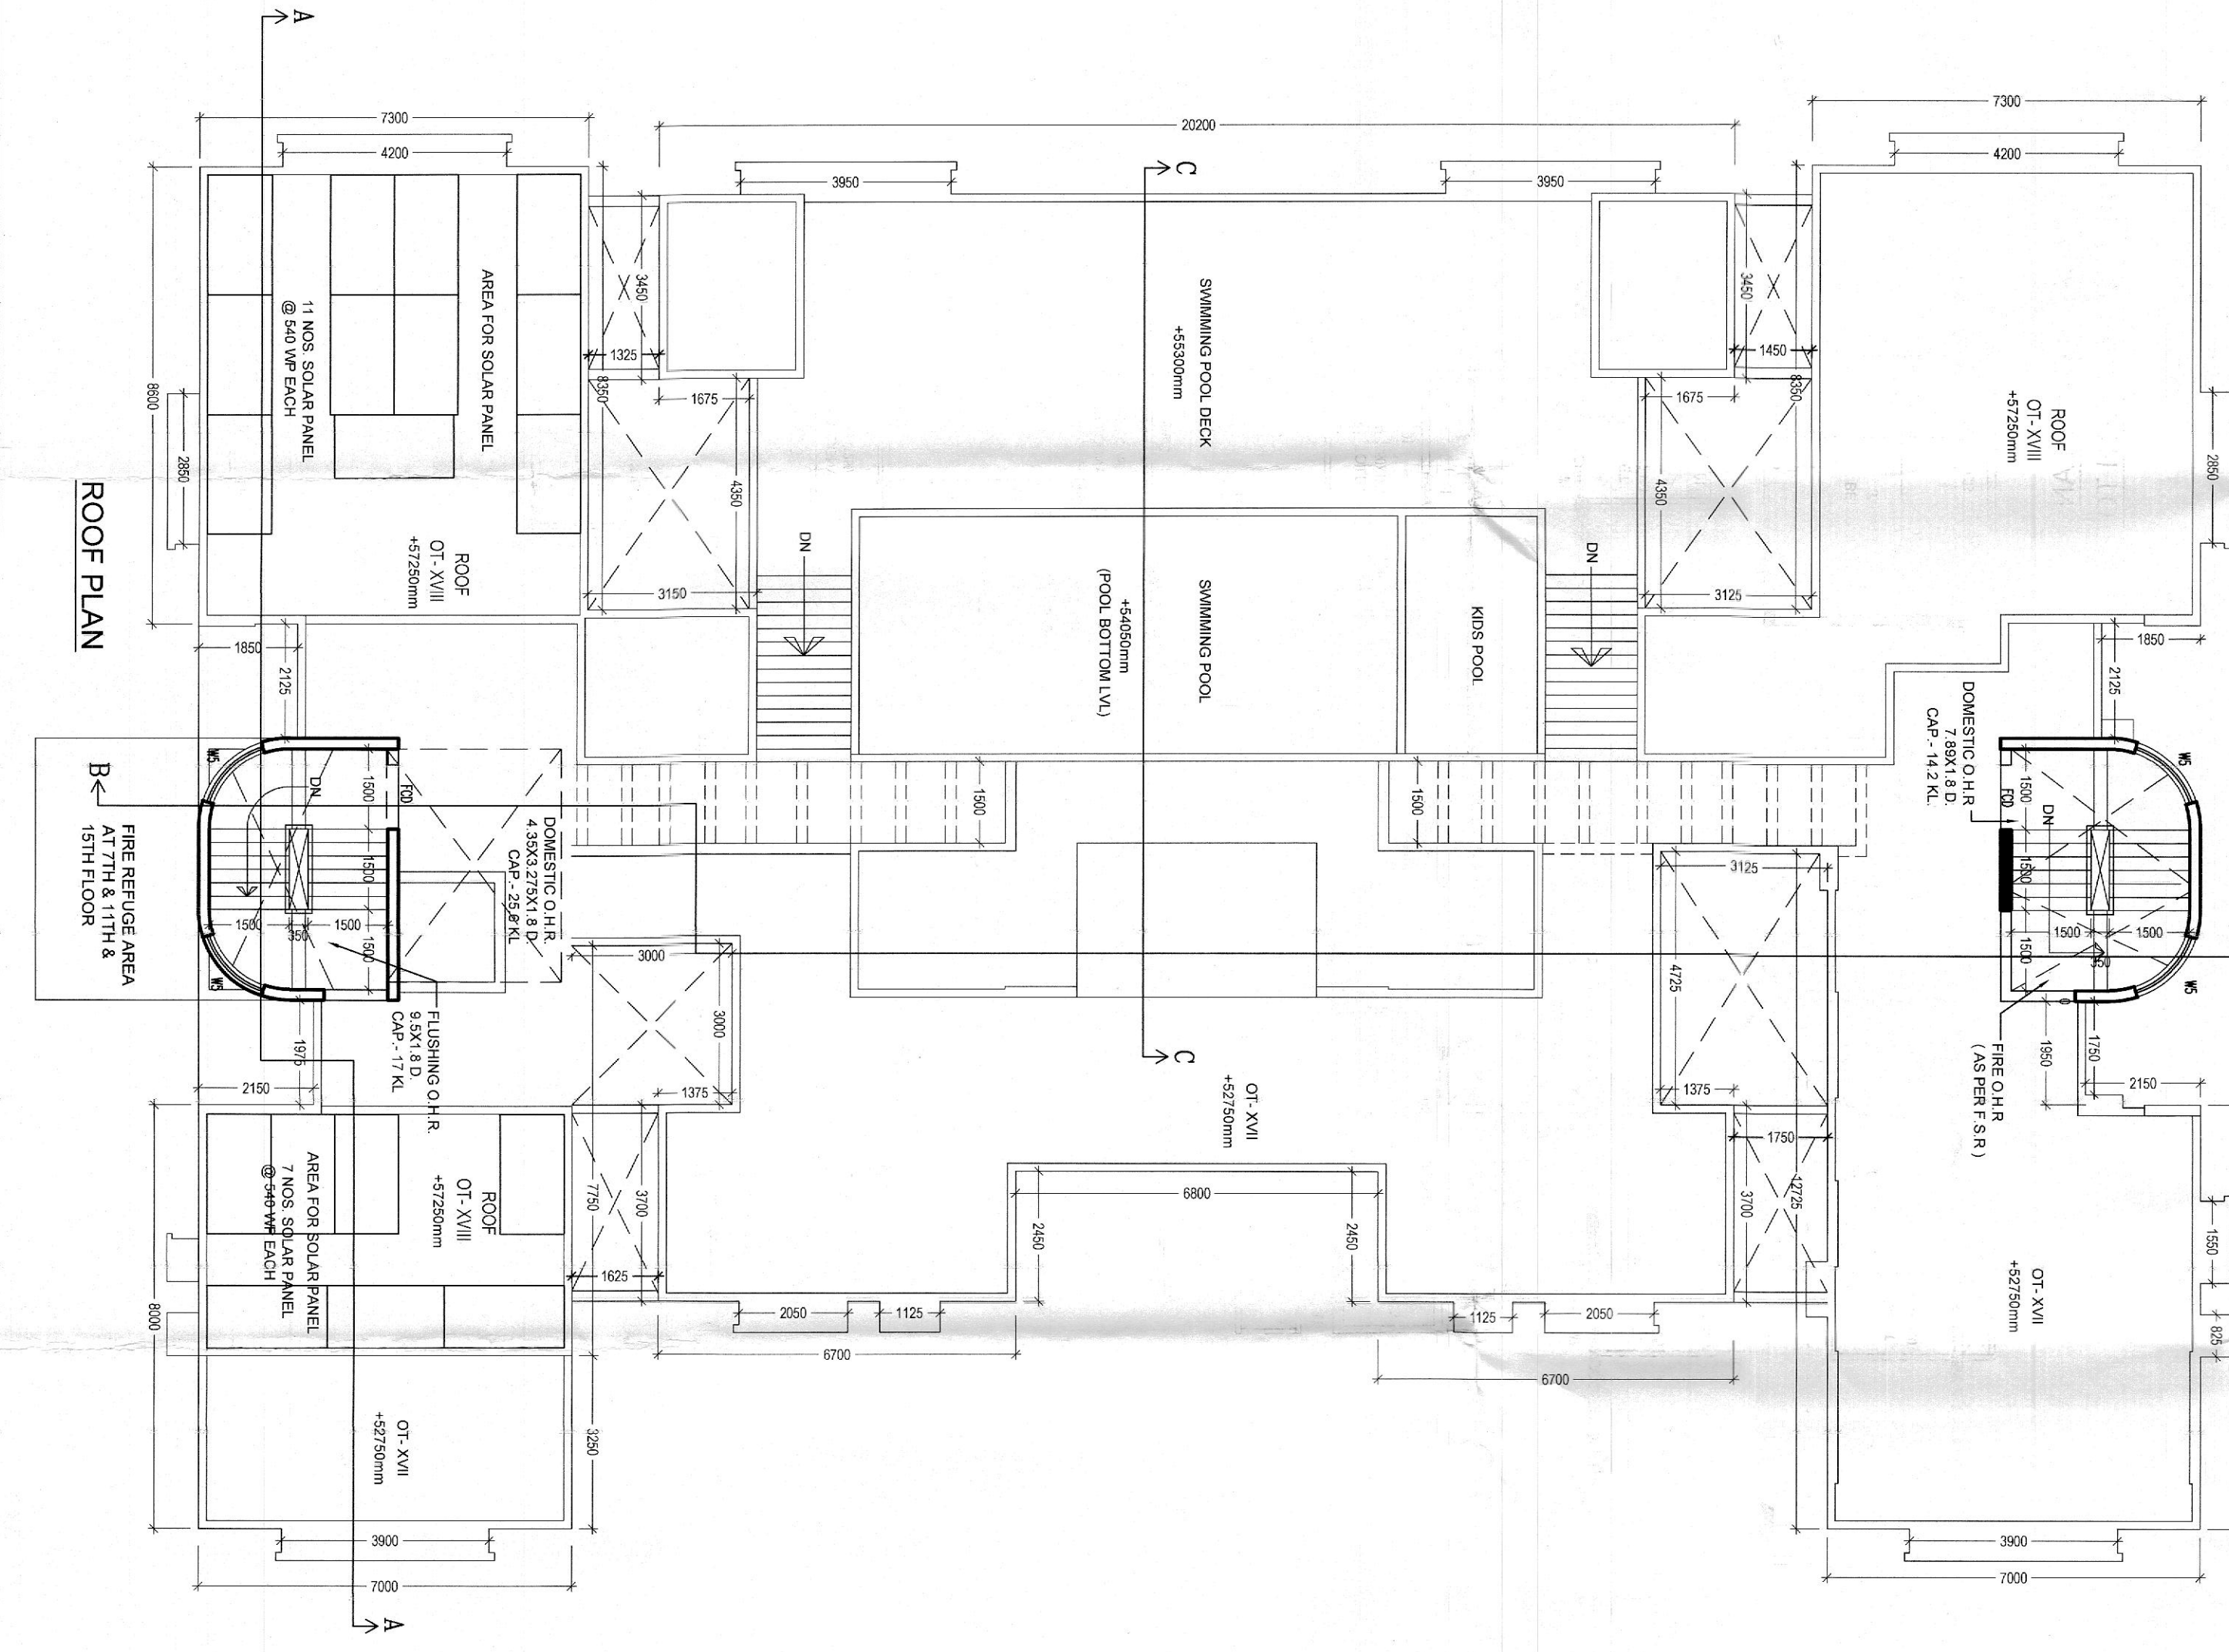
PROPOSED PLAN OF G+XIII (57.26 M. H.T.) STORED RESIDENTIAL BUILDING USE 3534 OF KMC ACT 1980, COMPLIANCE WITH KMC BUILDING RULE 2008, AT PEE NO. - 50A, BAKSHATI ROAD,

WARD NO.-14, BOBOLIGH - XII, P.O.-JOKA, KOLKATA-104
P.S.-THAKURPUKUR, WITHIN KOLKATA MUNICIPAL CORPORATION.

[illegible][illegible]

SECTION C-C THROUGH SWIMMING POOL

The diagram shows a cross-section of a building with multiple levels. The central feature is a vertical shaft labeled "LIFT SHAFT". To the left of the shaft, there are several levels of rooms, including "BED ROOM", "LIFT LOBBY", and "BED ROOM". To the right of the shaft, there are also several levels of rooms, including "BED ROOM", "LIFT LOBBY", and "BED ROOM". The building is surrounded by a "SWIMMING POOL" and a "CAR PARKING" area. The diagram includes various dimensions and labels for different parts of the building, such as "BED ROOM", "LIFT LOBBY", "BED ROOM", "LIFT SHAFT", "SWIMMING POOL", and "CAR PARKING".

[illegible]

IT IS A CONDITIONAL SANCTION VIDE MBC RESOLUTION MEETING NO.641 DATED-29.08.2024
MBC ITEM NO - 107/24-25 AND REFERRED RESOLUTION RELAXED BY D.G(B) DATED 04.10.2024

SPECIFICATIONS 1. R.C.C. FRAME STRUCTURE WITH CONCRETE GRADE 1:1:3. 2. 190MM. THK R.C.C. EXTERNAL WALL & 100MM THK INTERNAL BRICK WALL. 3. STEEL 2. SECTION WORKING. 4. CAST-IN SITUATION FLOORING. 5. T.N.B & TENDER SPECIFICATION INTERNAL WALLS AND CEILING RESPECTIVELY. 7. F.O.P. FINISH ON INTERNAL WALLS & CEILING.	
B.P. NO. :- 2025/011018 DATED :- 19.06.2025 VALID UPTO :- 18.06.2030 MRC MEETING NO. 641 MRC MEETING DATE :- 09.08.2024 MRC ITEM NO :- 107/24-55	
ARCHITECT 26/2 Bangalore Central Road, Ideapark Park Hall No. 7, 5th Floor, Vokalia 760193 TEL: (083) 4904242-5 www.immagine.com APPROPRIATE PLANNING OFFICERS IMMAGINE	
THIS DRAWING IS A PRIVATE AND CONFIDENTIAL DOCUMENT AND IS NOT TO BE REPRODUCED OR WITHHELD WITHOUT THE CONSENT OF M/S IMVAVE	
PROJECT PROPOSED PLANT OF 60MM (57.52M) HLT STORED RESIDENTIAL WATER TANK WITH 200 TONNAGE WATER TANK WITH 400 TONNAGE BUILDING AT 200/4 - 1ST PO, 100A KADAKATTAH, WARD NO. 144, BENDROU-2, P.O. 100A KADAKATTAH, P.S. THANDURUPPET, WITHIN KADAKATTA MUNICIPAL CORPORATION	