


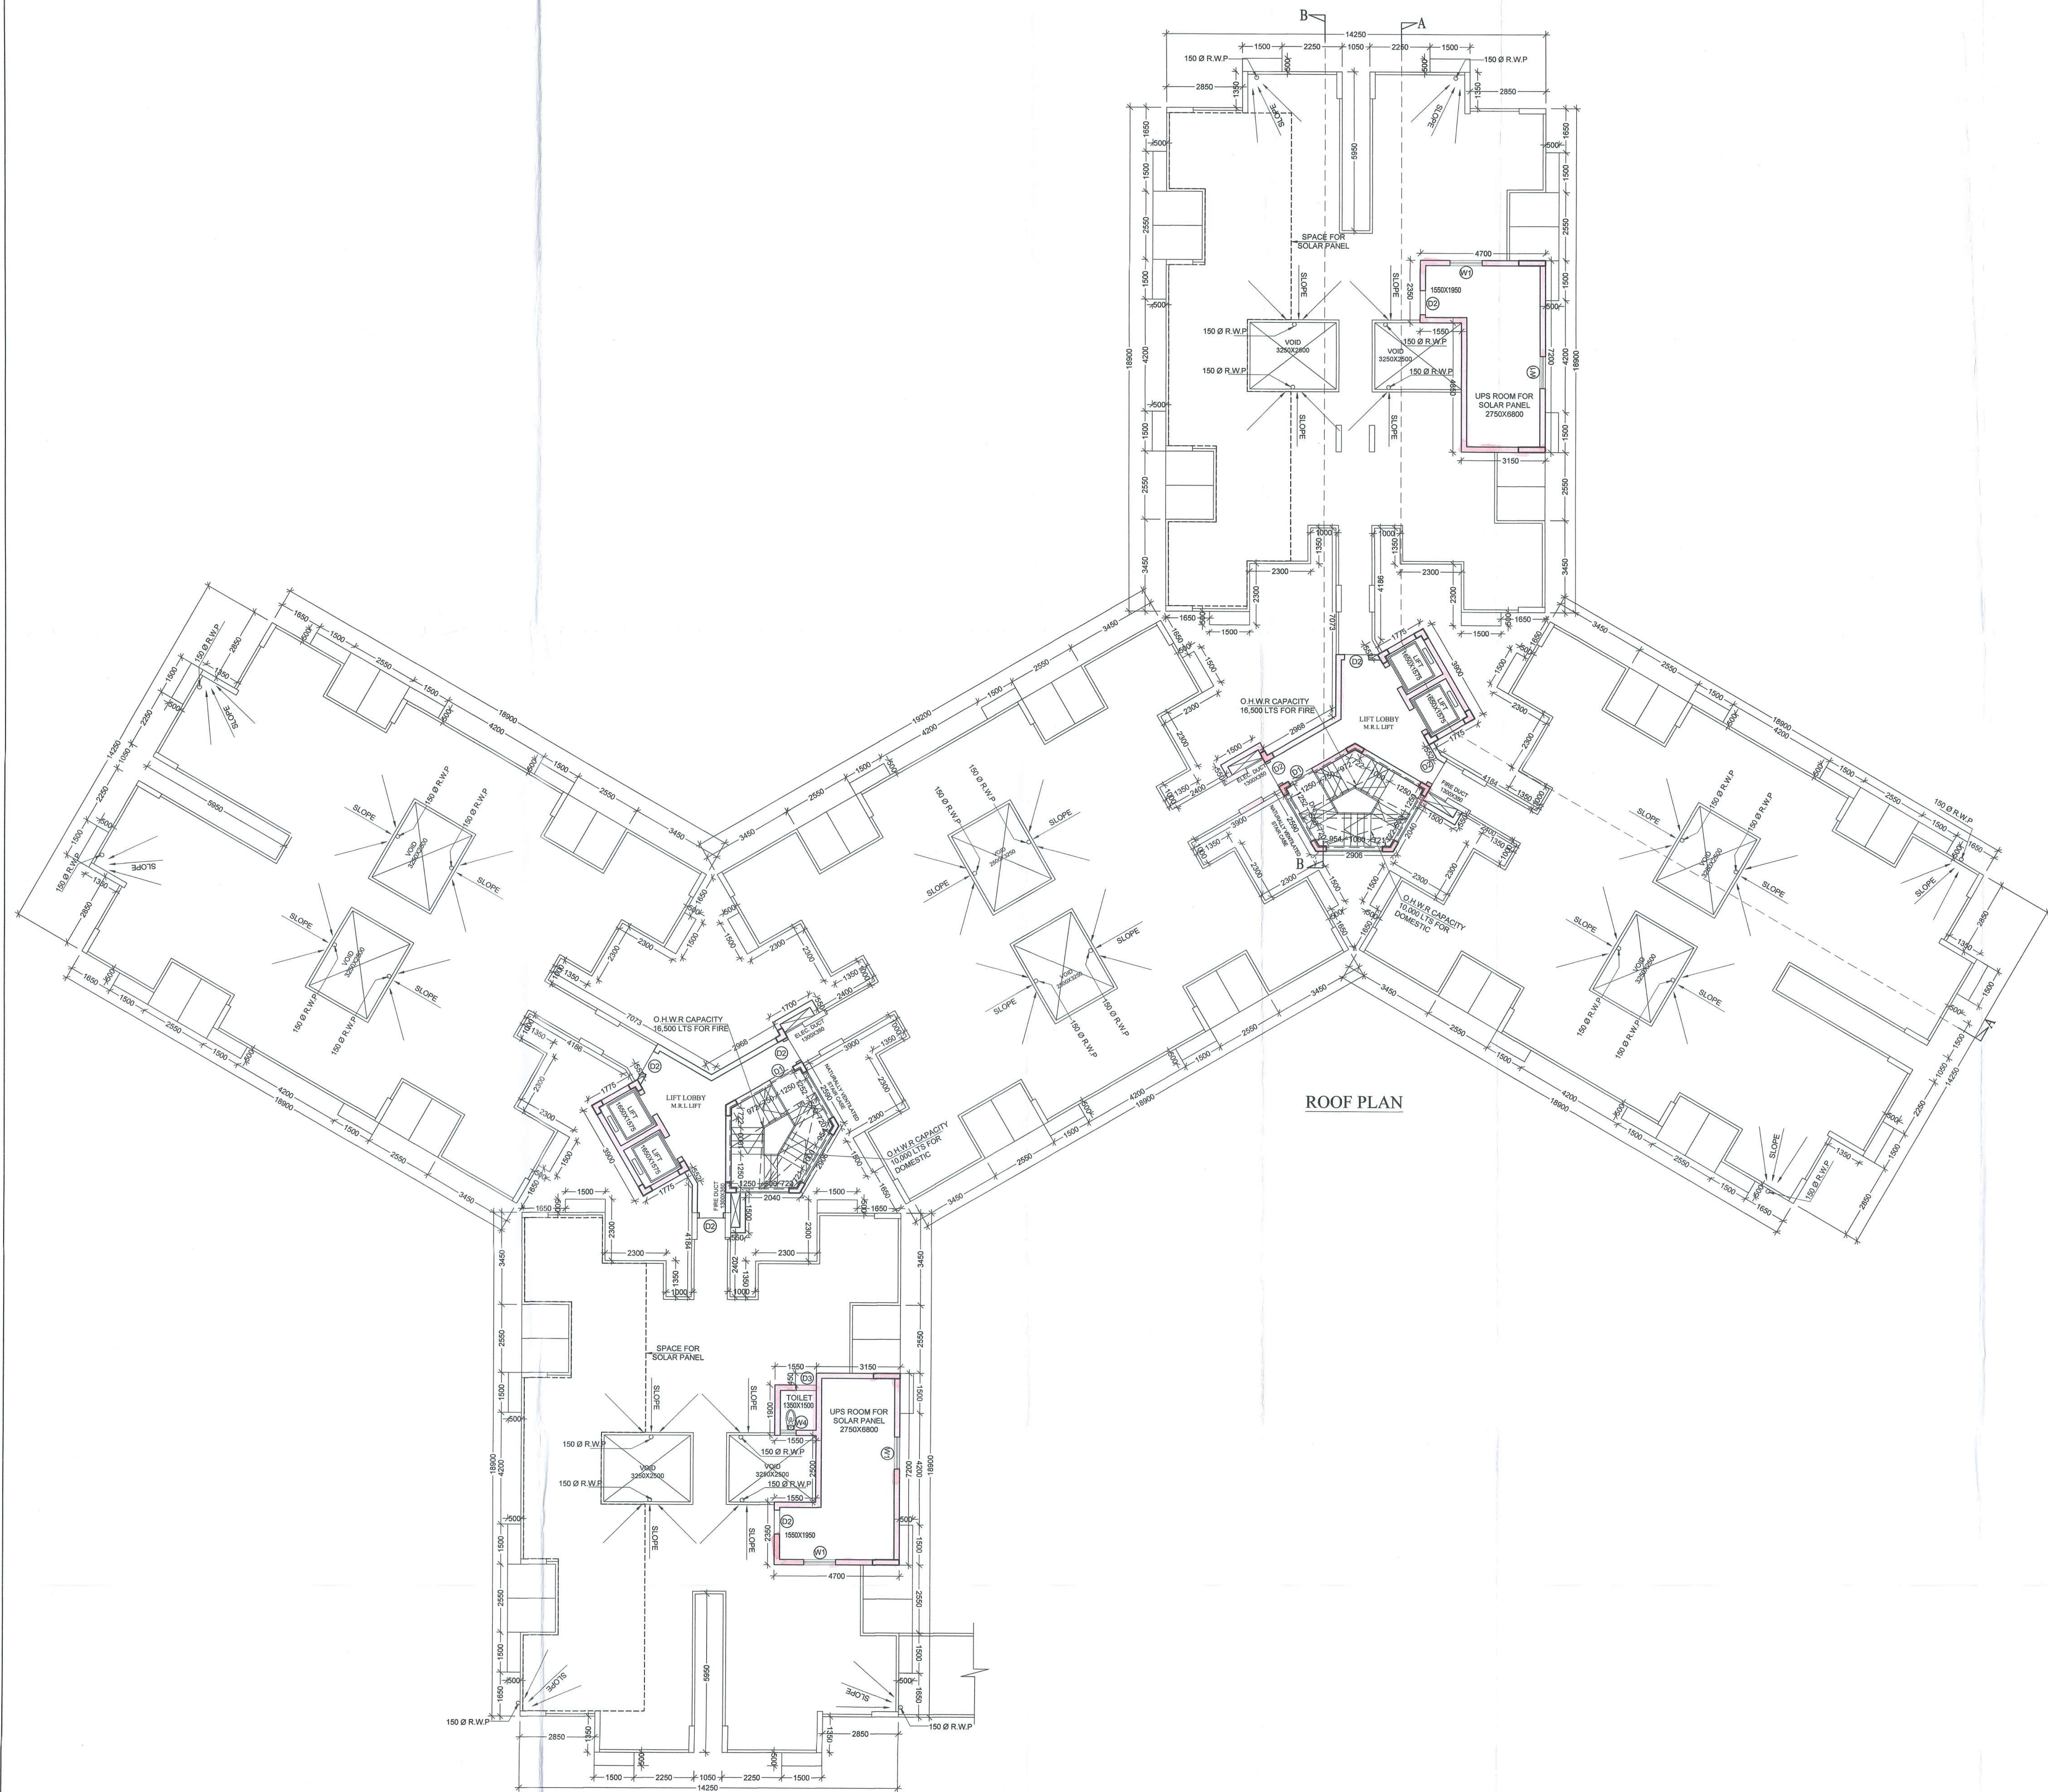

PROJECT
PROPOSED G+12 STOREY AFFORDABLE HOUSING UNDER PRADHAN MANTRI AWAS YOJANA AT MUNICIPAL HOLDING NO. 31, KANAILAL GOSWAMI SARANI, UNDER CIRCLE NO. 'F', OF THE SERAMPORE MUNICIPALITY COMPRISED IN L.R. DAG NOS. 2588, 2589, 2597, 2598, 2603, 2604, 2605, 2607, 2608, 2609, 2610, 2611, 2612, 2614, 2615, 2616, 2617, 2618, 2619, 2620, 2621, 2622, 2623, 2624, 2625, 2626, 2627, 2628, 2629, 2631, 2642, MOUZA: MAHESH, P.S. SERAMPORE, J.L.: 15, L.R. KHATIAN NO. 11337, P.O. SERAMPORE, PIN: 712201, DISTRICT HOOGHLY, WEST BENGAL.

OWNER:
EDEN REALITY PVT. LTD.

TITLE:

ROOF PLAN & ELEVATION (TYPE-9)

SCHEDULE OF DOORS & WINDOWS					
DOORS			WINDOWS		
TYPE	WIDTH	HEIGHT	TYPE	WIDTH	HEIGHT
D1	1000	2100	W1	1200	1200
D2	900	2100	W2	1000	1200
D3	750	2100	W3	900	900
SD1	2250	2100	W4	600	900
SD2	2550	2100	W5	750	1200
			W6	800	425
			W7	600	425

SPECIFICATION
1. ALL DIMENSIONS ARE IN MM UNLESS IT IS MENTIONED.
2. ALL EXTERNAL BRICK WALLS ARE 200 MM THICK AND INTERNAL 100 MM THICK.
3. ALL BRICKWORK PLASTERING INSIDE OR OUTSIDE ARE IN THE RATIO OF 1:6 & 1:4 RESPECTIVELY AND OUTSIDE PLASTERING CONTAINS WATER PROOFING.
4. ALL CIVIL WORKS ARE AS PER IS 456 AND ALL REINFORCEMENT AS PER IS 1176.
5. ALL R.C.C. WORKS ARE IN THE RATIO M-25.
6. ALL PRECAUTIONARY MEASURES SHALL BE TAKEN AT THE TIME OF CONSTRUCTION.
7. DEPTH OF WATER RESERVOIR SHALL NOT BE MORE THAN THE DEPTH OF MAIN COLUMN FOUNDATION.

EDEN INFRACON PRIVATE LIMITED
Kiran Sengupta Director
CONSTITUTED ATTORNEY OF PYRAMID ENCLAVE (P) LTD.

SIGNATURE OF OWNER
WE DO HEREBY CERTIFY THAT THE FOUNDATION AND SUPERSTRUCTURE OF THE BUILDING PROPOSED FOR CONSTRUCTION ON PREMISES NO. 31 KANAILAL GOSWAMI SARANI (PREVIOUSLY KNOWN AS RAILLAND ROAD) UNDER CIRCLE NO. 'F', OF THE SERAMPORE MUNICIPALITY COMPRISED IN L.R. DAG NOS. 2588, 2589, 2597, 2598, 2603, 2604, 2605, 2607, 2608, 2609, 2610, 2611, 2612, 2614, 2615, 2616, 2617, 2618, 2619, 2620, 2621, 2622, 2623, 2624, 2625, 2626, 2627, 2628, 2629, 2631, 2642, MOUZA: MAHESH, P.S. SERAMPORE, J.L.: 15, L.R. KHATIAN NO. 11337, P.O. SERAMPORE, PIN: 712201, DISTRICT HOOGHLY, WEST BENGAL HAVE BEEN SO DESIGNED BY ME/US WILL MAKE SUCH FOUNDATION AND SUPERSTRUCTURE SAFE IN ALL RESPECT INCLUDING THE CONSIDERATION OF BEARING CAPACITY AND SETTLEMENT OF SOIL ETC.

ALOK ROY
Empanelled Geotechnical Engineer
Kolkata Municipal Corporation
Class-I, No-C/1111
6A, Milan Park
Kolkata-700 084
SIGNATURE OF GEOTECHNICAL ENGINEER
GEOTECH ENGINEERS PVT. LTD.
ALOK ROY
CITE-1/11
6A, MILAN PARK, GARIA, KOLKATA-700084.

K. Sengupta
Signature of Struct. Reviewer
KOUSHIK SENGUPTA
B.Sc. (Civil) (Hons.)
KOLKATA MUNICIPAL CORPORATION
SIGNATURE OF STRUCTURAL ENGINEER
BIBEK BHASKAR MULLICK
SIGNATURE OF STRUCTURAL REVIEWER
KOUSHIK SENGUPTA

Malay Kumar Ghosh
MALAY KUMAR GHOSH
Regn. No. CA/82/14854
35A, Dr. Sarat Banerjee Road
Kolkata - 700 029
SIGNATURE OF ARCHITECT
MALAY KUMAR GHOSH
REGN. NO. CA/82/14854
35A, DR. SARAT BANERJEE ROAD,
KOLKATA-700 029

SCALE 1:100 **REF. NO.**
DATE 26.02.19 **DRG. NO.** ESP/2018/EDEN SERAMPUR/SANC/ARCH-9-04
DEALT P.D.S.B. **DESIGNED** M.G.

ARCHITECTS
ESPACE
35A, DR. SARAT BANERJEE ROAD,
KOLKATA 700-029
PH: 2465-4130, 4159

THIS DRAWING IS A PROPERTY OF ESPACE, 35A, SARAT BANERJEE ROAD, KOLKATA-700 029. ANY MODIFICATION, CHANGES, DEVIATIONS IS NOT PERMISSIBLE WITHOUT PRIOR INTIMATION TO ESPACE IN THE CONTRARY, THIS WILL BE TREATED AS ILLEGAL ACT.

ARC4-9-04
(TYPE-9)
RMP PLAN
SMB

Petition No. 754 of 2018-19
Permission for the new construction as
proposed and shown in the plan is granted
Vale SI No. 6, 6, 6, 6 and corresponding
R.O.C. Meeting Dt. 22.9.2018
Dated.....Chairman.....

7/6/18

Serampore Municipality
This plan is valid for three years and may
be revalidated for the further two years on
payment of necessary charges with production
of original plan showing with prescribed form.
2. Within one month after the completion of new
construction or a suitable portion thereof, the
owner must be informed that the Municipal
Authority for interim assessment on a prescribed
form.

Chandrasekar Chakrabarti
Urban Infrastructure Expert
Serampore Municipality

Nishanjan Banerjee
Technical Advisor & Consulting
Engineer
Field Chief Engineer M.E.D.
Serampore Municipality